


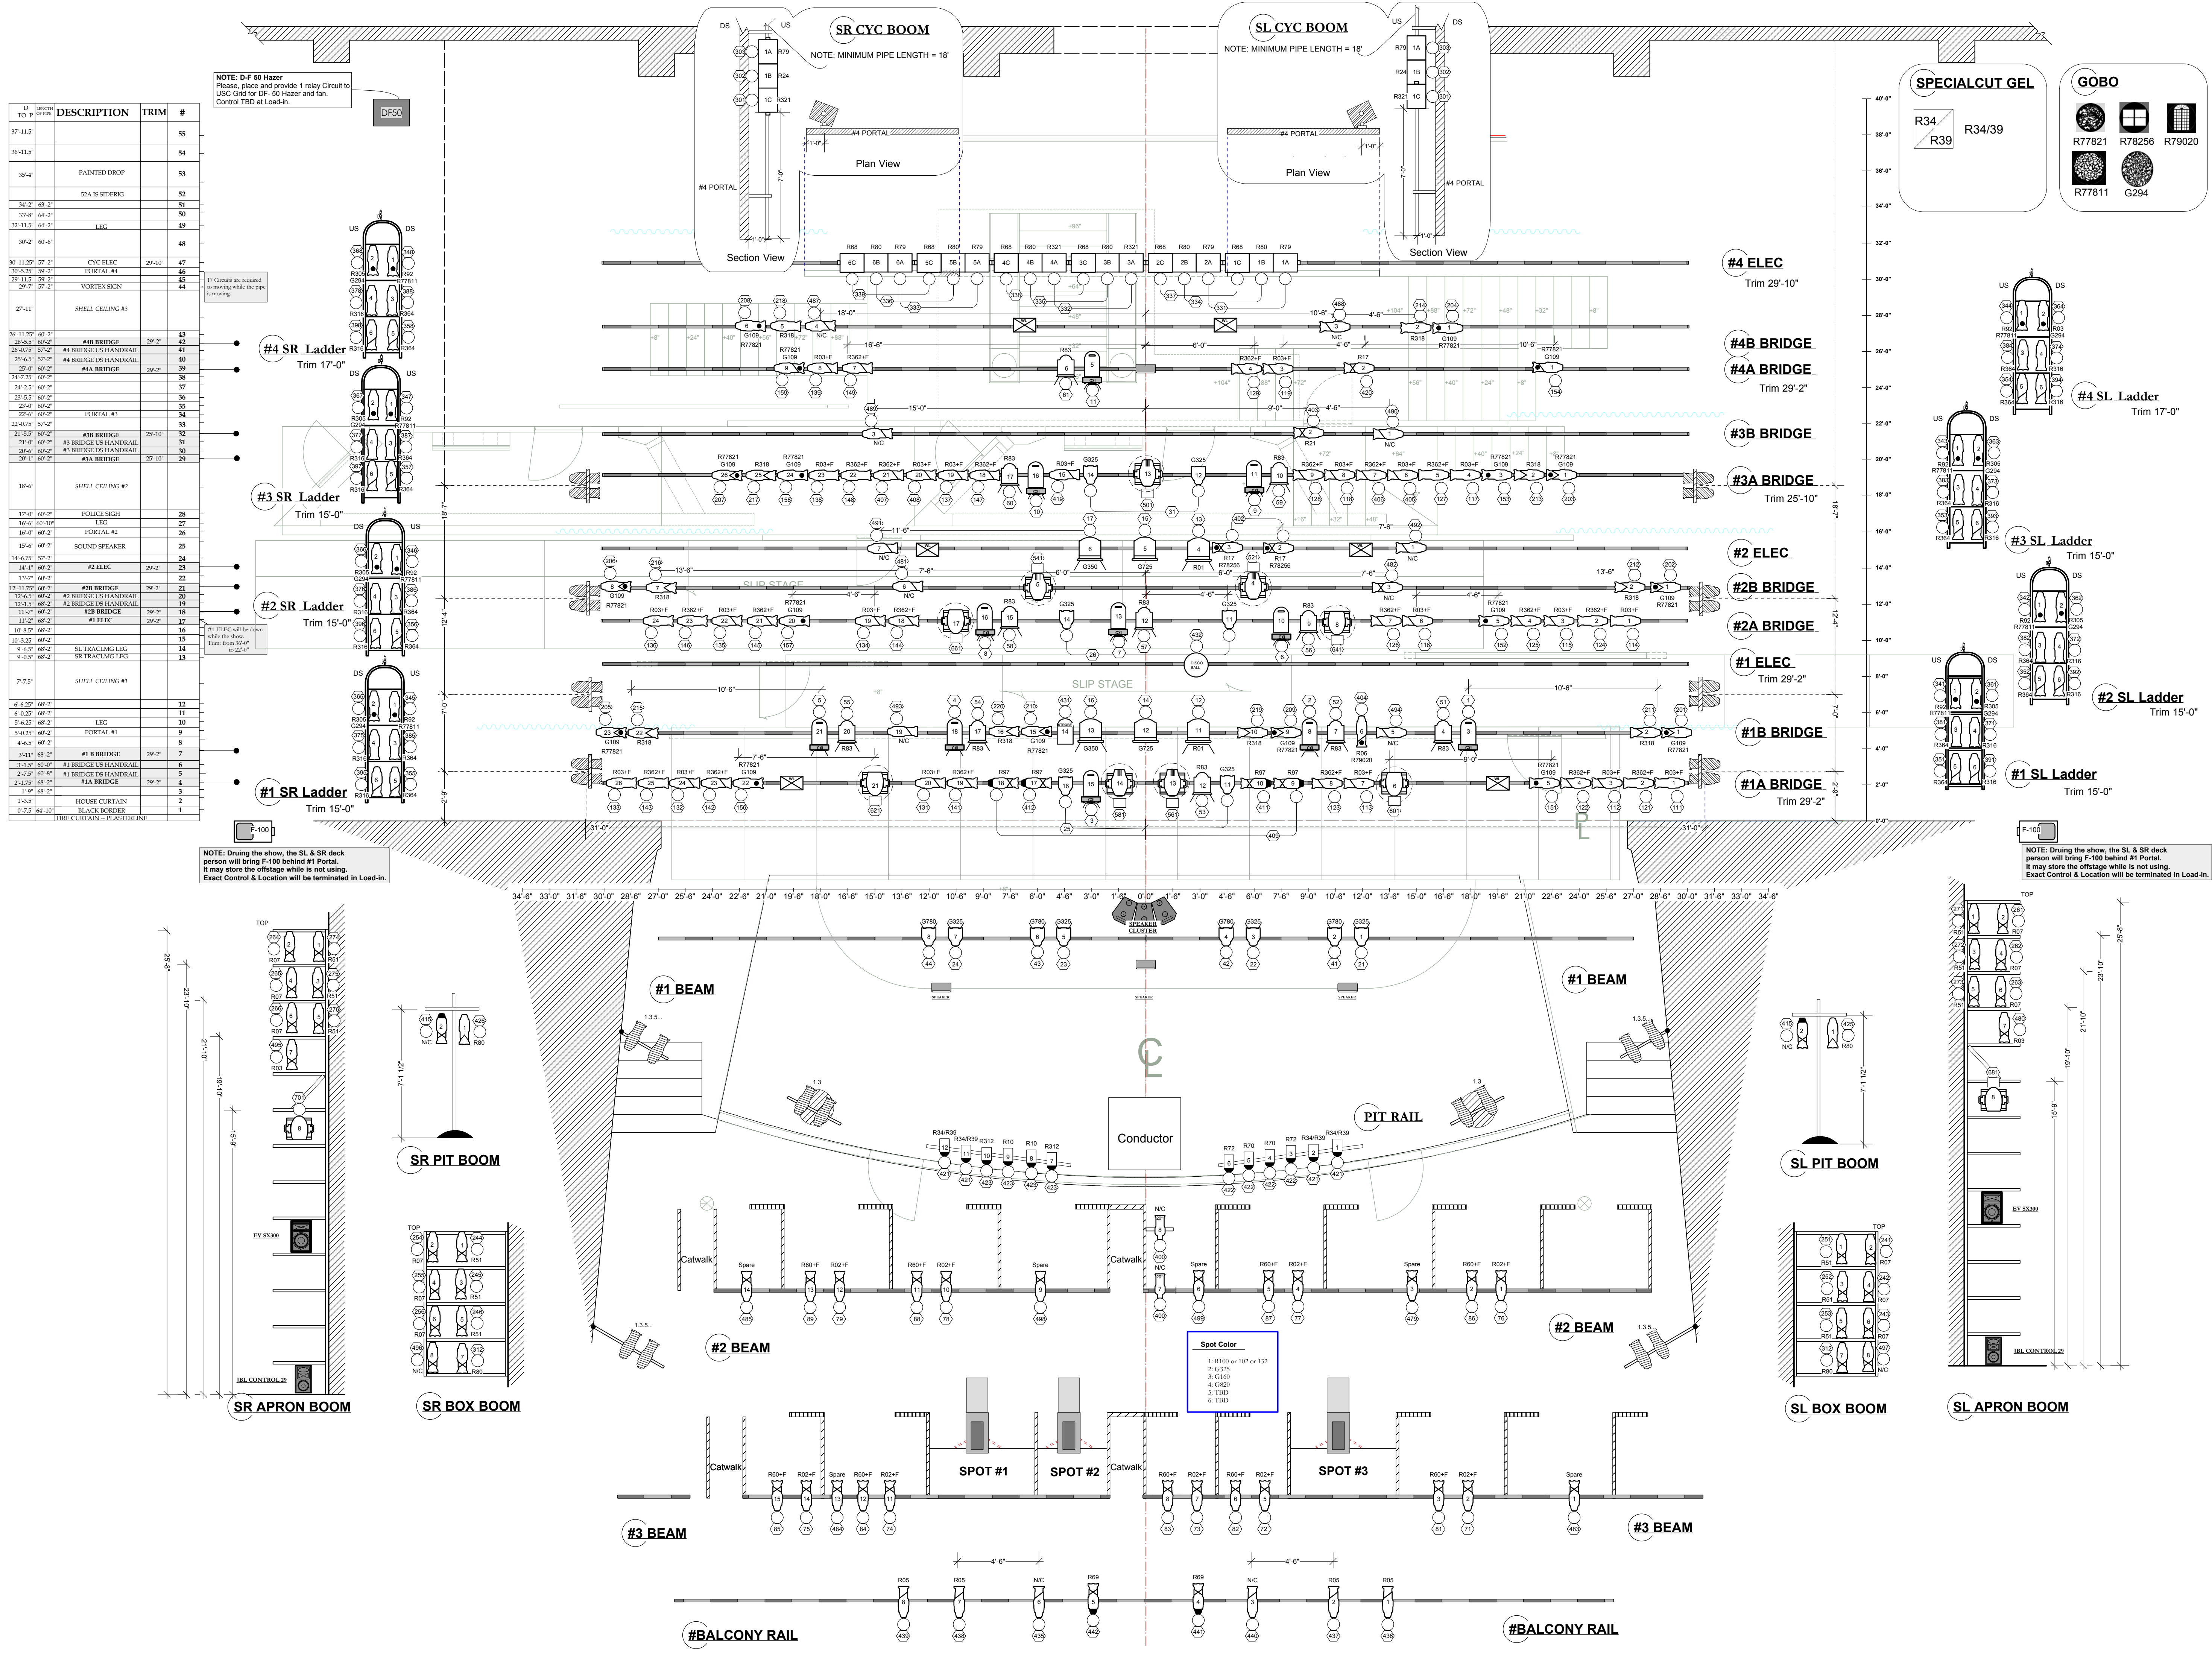

KEY TO SYMBOLS

Source Four 19" 575W	Source Four 26" 575W
Source Four 36" 575W	Source Four 50" 575W
Source Four PAR MFL 375W	Source Four PAR WFL 375W
8" Fresnel 2kW	12" Fresnel 5kW
Martin MAC 300 SPOT 575W	Martin MAC 600 Wash 575W
PAR64 MFL 1KW	PAR 46-ACL 230W
Source 4 19 750W	PAR 64 Strobe
3" Fresnel 150W	16" Disco Ball
Super Arc 400 Model 1267-1200W	
Stand Iris Cyc 1000w	
F-100 Fogger	DF-50 Hazer
Wybron CX1 Color Fader	6.25" Dount
12" Barndoor	6.25" Top Hat
7.5" Barndoor	10" Barndoor

TYPICAL

Conventional Moving Light

Unit # 1

Address Channel

NOTES:

- BEAMS NOT TO SCALE IN RELATION TO PLASTER LINE.
- ALL UNITS ARE ON 18" CENTER UNLESS DIMENSIONED OTHERWISE.
- LINE SETS ARE EXPANDED FOR CLARITY.
- ALL ITEMS SHOWN ON PLOT TO BE INSTALLED AT LOAD-IN (11/3/07).
- PLEASE INCLUDE GEL FRAMES WITH ALL INSTRUMENTS.
- TYPICAL ABBREVIATIONS:
 - R - ROSCO
 - G - GAM
 - L - LEE
 - N/C - NO COLOR
 - F - R132
- ALL FIXTURES LABELED WITH "T" MUST HAVE R132 IN ADDITION TO OTHER GEL.
- ALL INSTRUMENTS IN APRON ROOMS MUST RECIEVE TOP HATS.
- FOR LOAD IN HAVE THE REST OF TOP HATS AND HALF HATS AVAILABLE.
- PLEASE HAVE ALL MOVING LIGHTS ADDRESSED PRIOR TO LOAD-IN.
- TRIMS SET FROM SHOW DECK TO BOTTOM OF PIPE
- FOR LOAD IN HAVE EXTRA R132 AND BARN DOORS AVAILABLE
- ALL TRIMS SHOULD BE TAKEN FROM BOTTOM OF PIPE TO SHOW DECK.
- PLEASE TRIM LADDERS FROM BOTTOM PIPE OF THE LADDER TO THE SHOW DECK

University of Cincinnati

COLLEGE-CONSERVATORY OF MUSIC

CORBETT AUDITORIUM

Wonderful Town

Lighting Design: Jakyung Sea

Director.....Dianne Iala
 Conductor.....Roger Grodsky
 Scenic Designer.....Brian Ruggaber
 Costume Designer.....Reba Senske
 Assistant L.D.....Lindsay Van Dyke
 Master Electrician.....Robert Moyer

LIGHT PLOT

SCALE: 1/4" = 1'-0"

DRAWN BY: JS, AZ & LYD


File Name: Plate #1 Plot 10.23.07.ver. 1 by JS

Prelim Due: October 15, 2007
 Final Due: October 22, 2007
 Load-In: November 3, 2007
 Strike: November 18, 2007


PLATE

1


OF 5

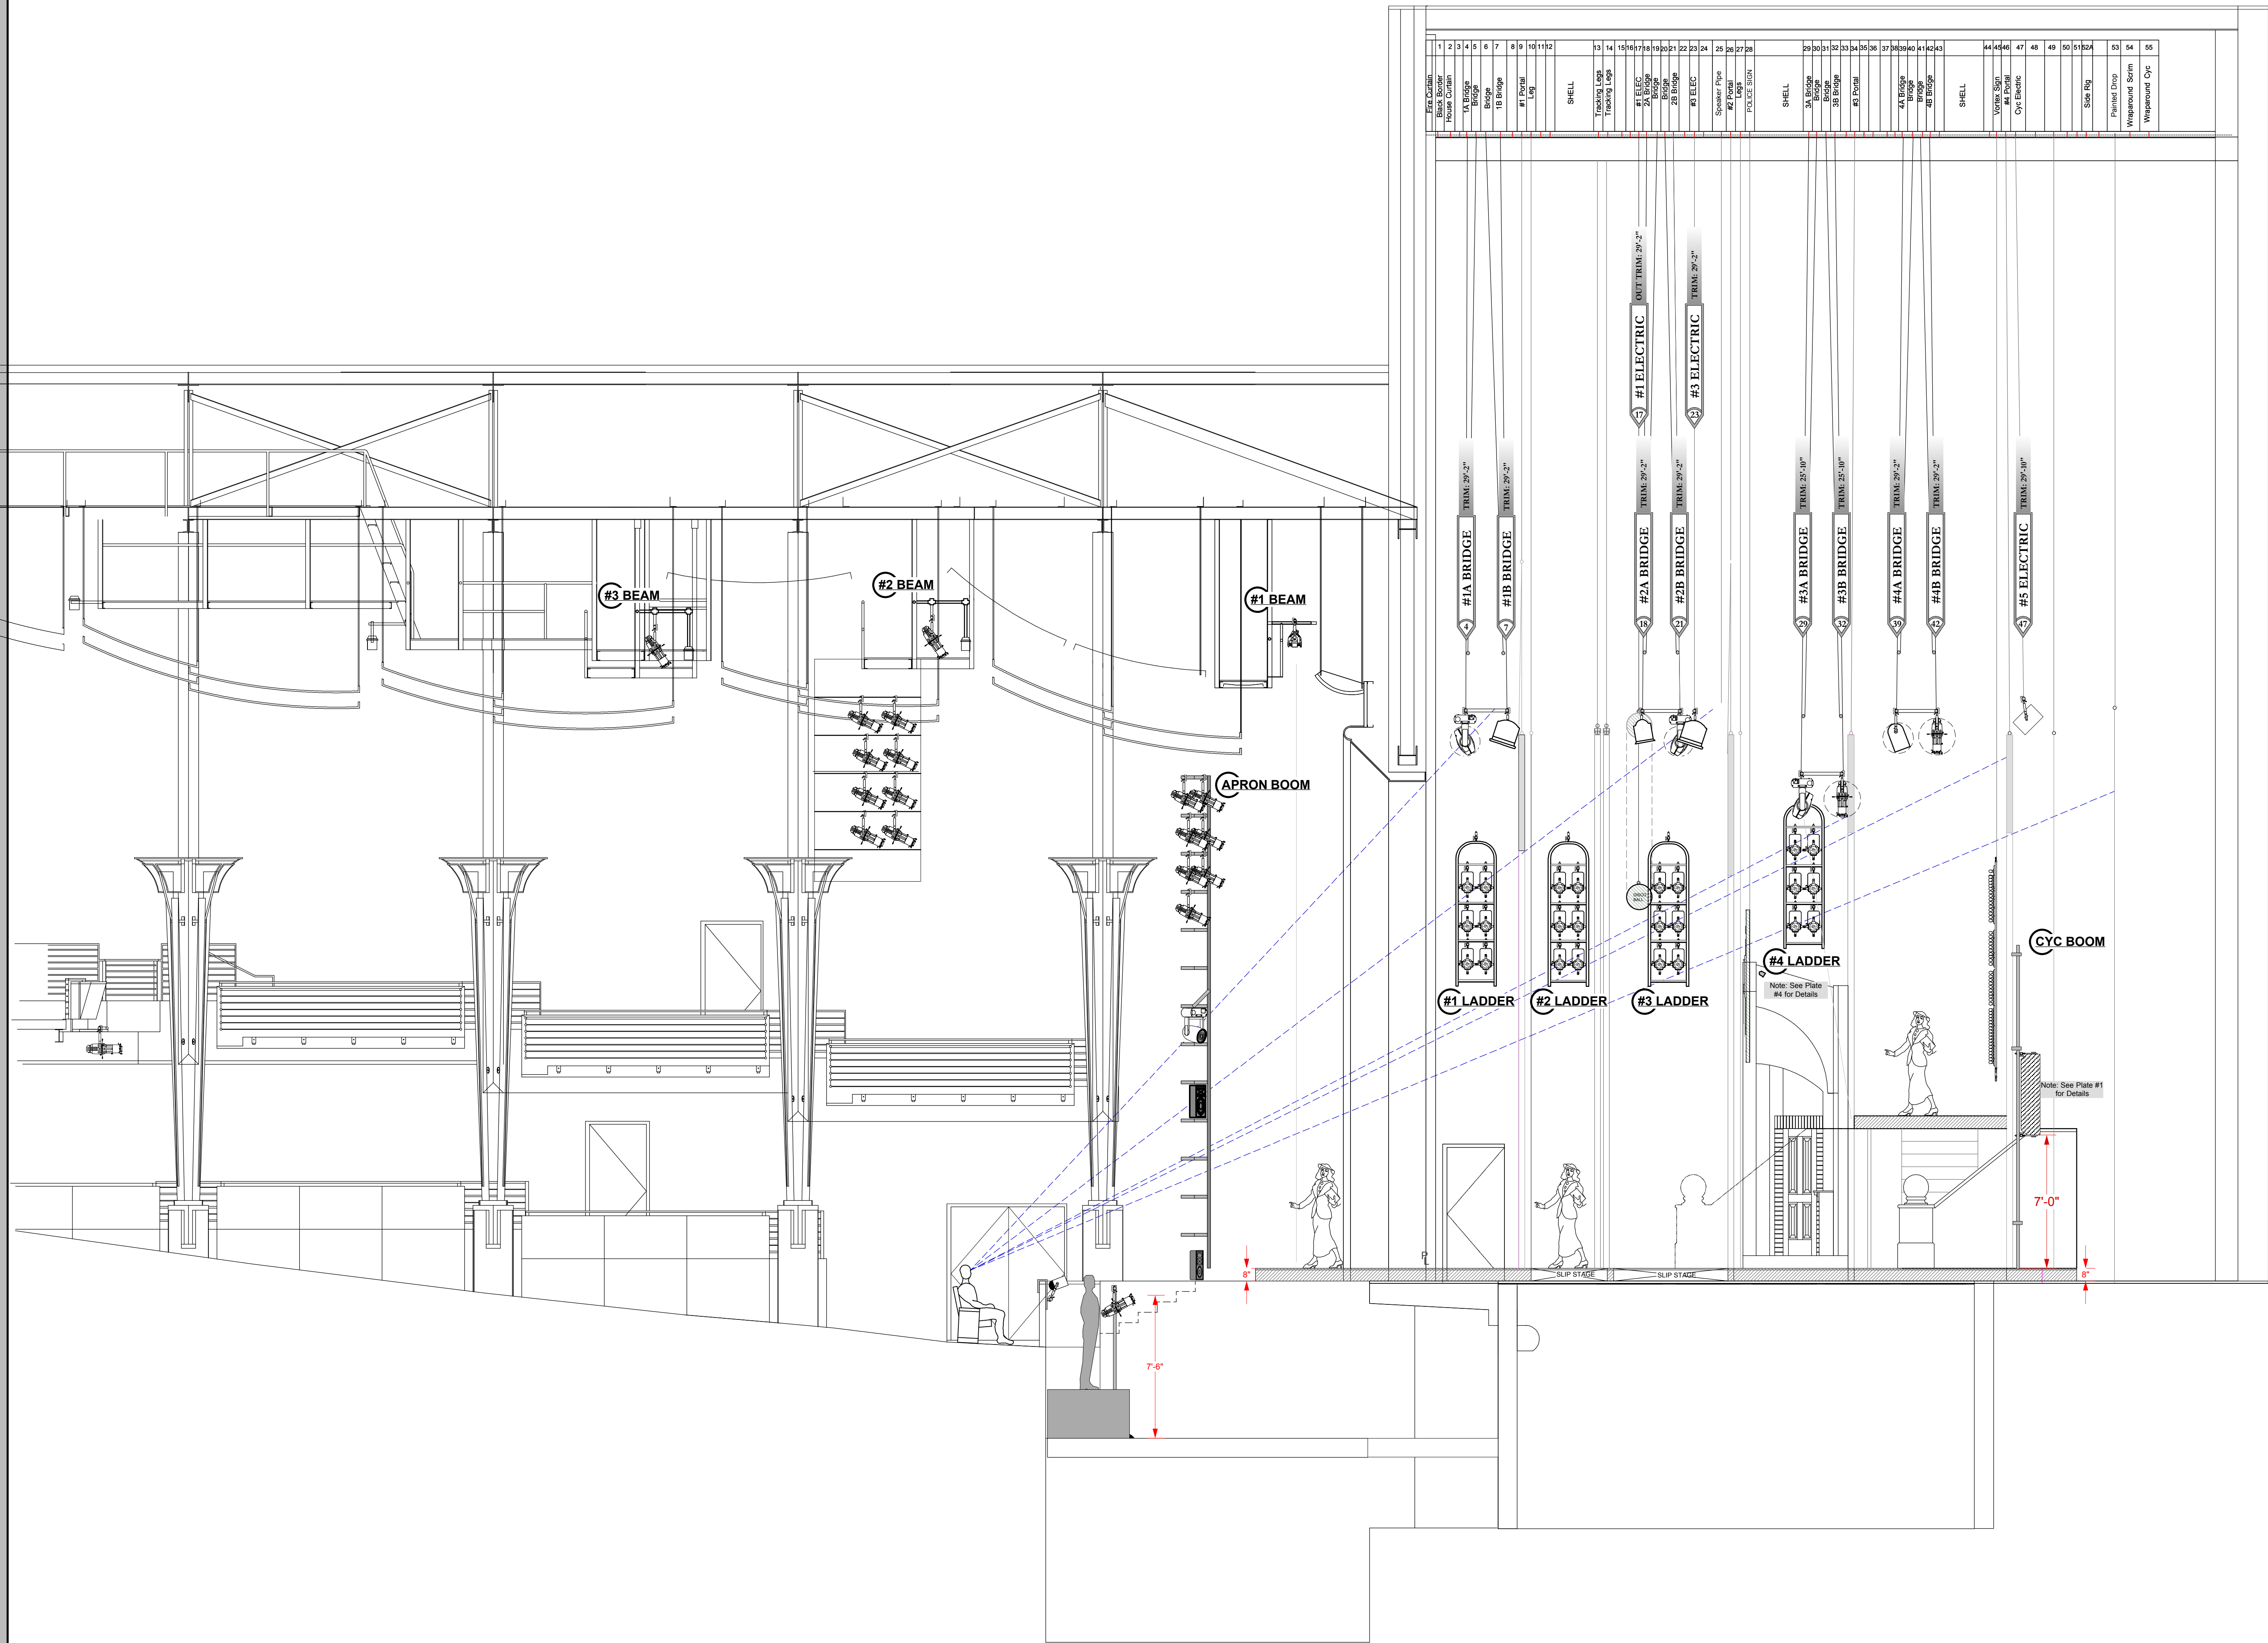

KEY TO SYMBOLS

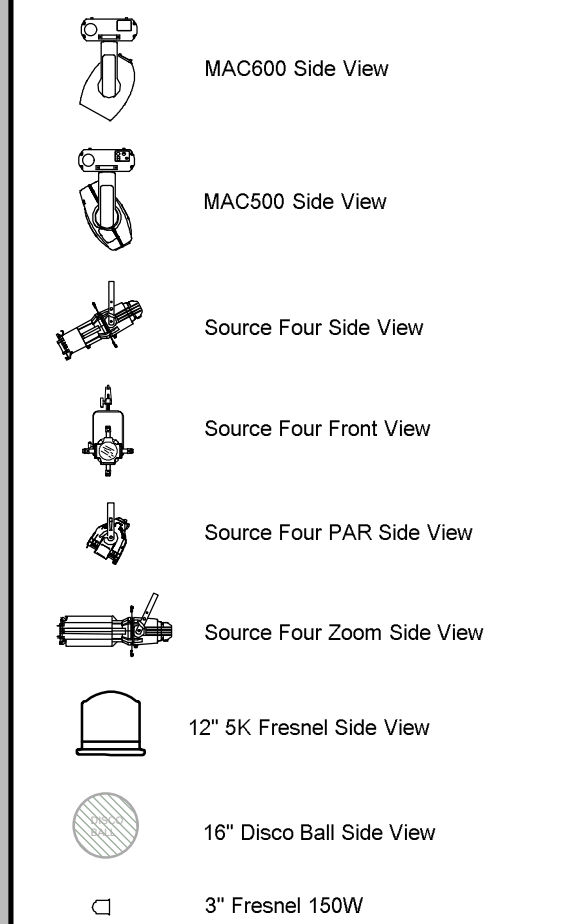

TYPICAL

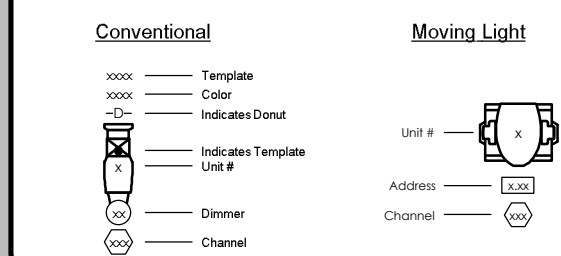

NOTES:

- BEAMS NOT TO SCALE IN RELATION TO PLASTER LINE
- ALL UNITS ARE ON 18" CENTER UNLESS DIMENSIONED OTHERWISE
- LINE SETS ARE EXPANDED FOR CLARITY
- ALL ITEMS SHOWN ON PLOT TO BE INSTALLED AT LOAD-IN (11/3/07)
- PLEASE INCLUDE GEL FRAMES WITH ALL INSTRUMENTS
- TYPICAL ABBREVIATIONS:
 - R - ROSCO
 - G - GAM
 - L - LEE
 - N/C - NO COLOR
 - F - R132
- ALL FIXTURES LABELED WITH "F" MUST HAVE R132 IN ADDITION TO OTHER GEL
- ALL INSTRUMENTS IN APRON BOOMS MUST RECEIVE TOP HATS
- FOR LOAD IN HAVE THE REST OF TOP HATS AND HALF HATS AVAILABLE
- PLEASE HAVE ALL MOVING LIGHTS ADDRESSED PRIOR TO LOAD-IN
- TRIMS SET FROM SHOW DECK TO BOTTOM OF PIPE
- FOR LOAD IN HAVE EXTRA R132 AND BARN DOORS AVAILABLE
- ALL TRIMS SHOULD BE TAKEN FROM BOTTOM OF PIPE TO SHOW DECK
- PLEASE TRIM LADDERS FROM BOTTOM PIPE OF THE LADDER TO THE SHOW DECK

University of Cincinnati
COLLEGE CONSERVATORY OF MUSIC

CORBETT AUDITORIUM



Lighting Design: *Jakyeung Seo*

Director.....Dianne Lala
Conductor.....Roger Grodsky
Scenic Designer.....Brian Ruggaber
Costume Designer.....Reba Senske
Assistant L.D.....Lindsay Van Dyke
Master Electrician.....Adam Zeck
Master Electrician.....Robert Moyer

SECTION PLOT

SCALE: 1/4" = 1'-0"

DRAWN BY: JS, AZ, LVD





File Name: Plate #2 Section 10.21.07.ver.1 by J. mcd

Prelim Due: October 15, 2007
Final Due: October 22, 2007
Load-In: November 3, 2007
Strike: November 18, 2007


PLATE

2


OF 5

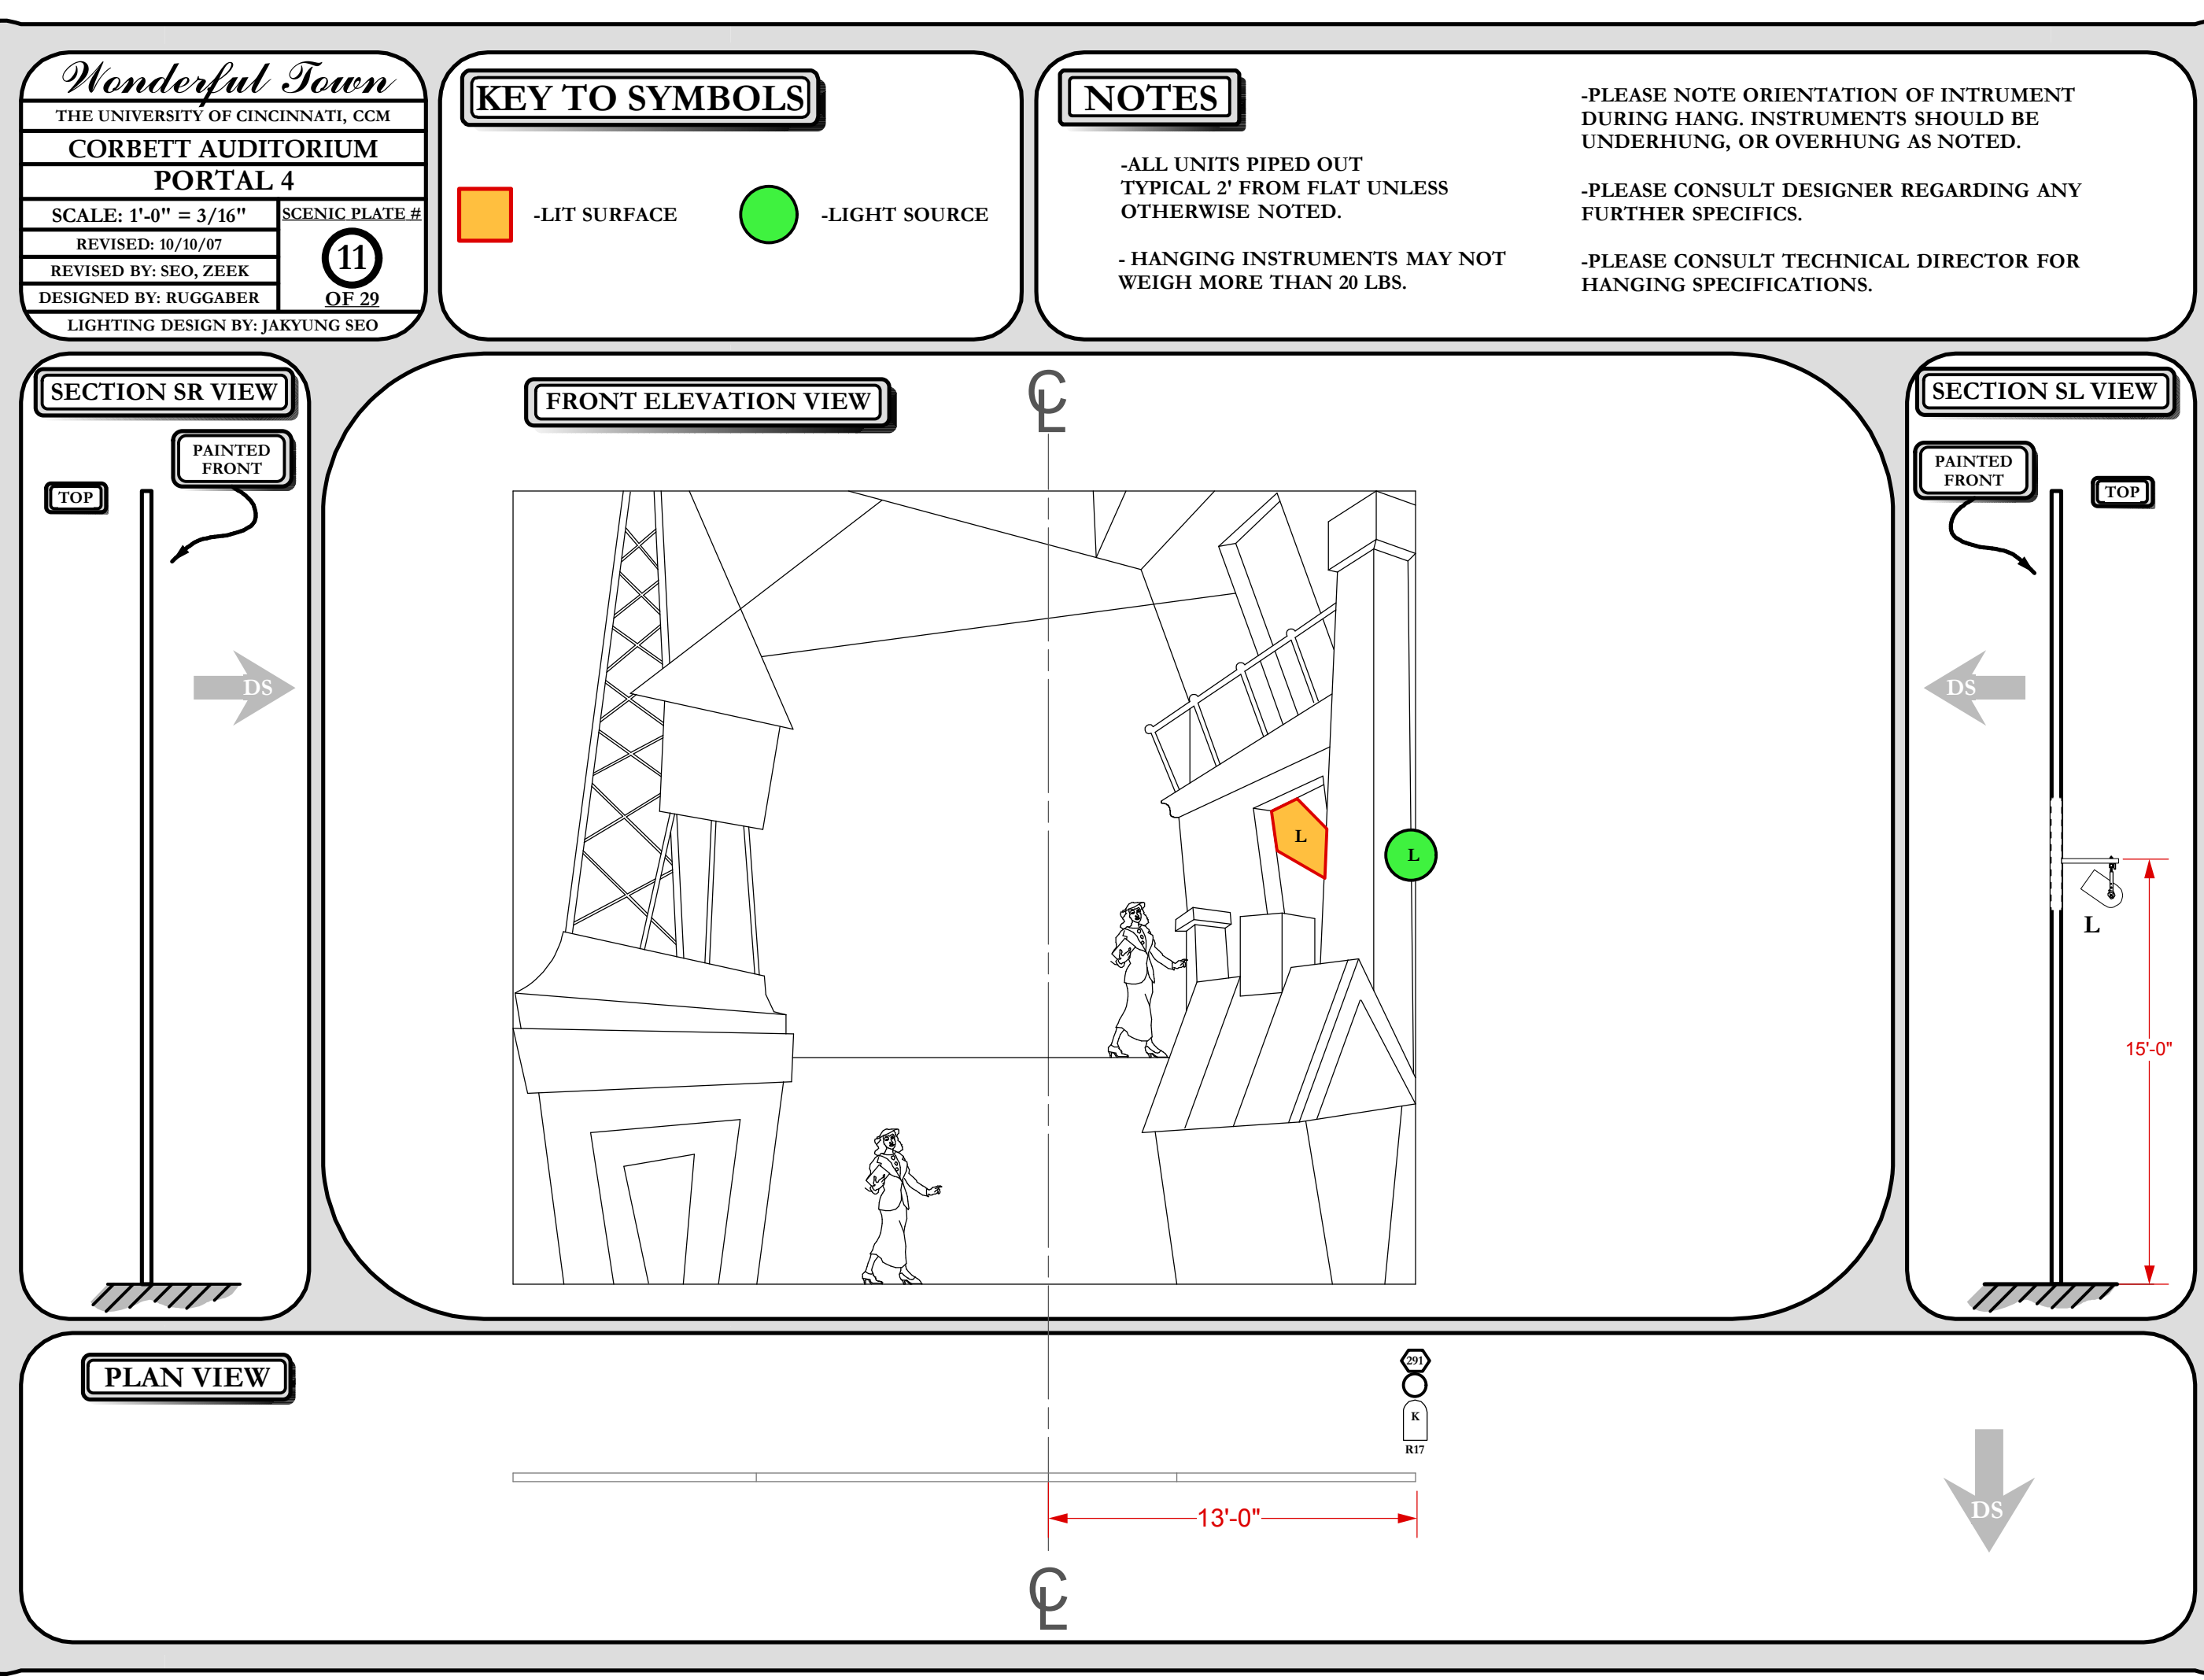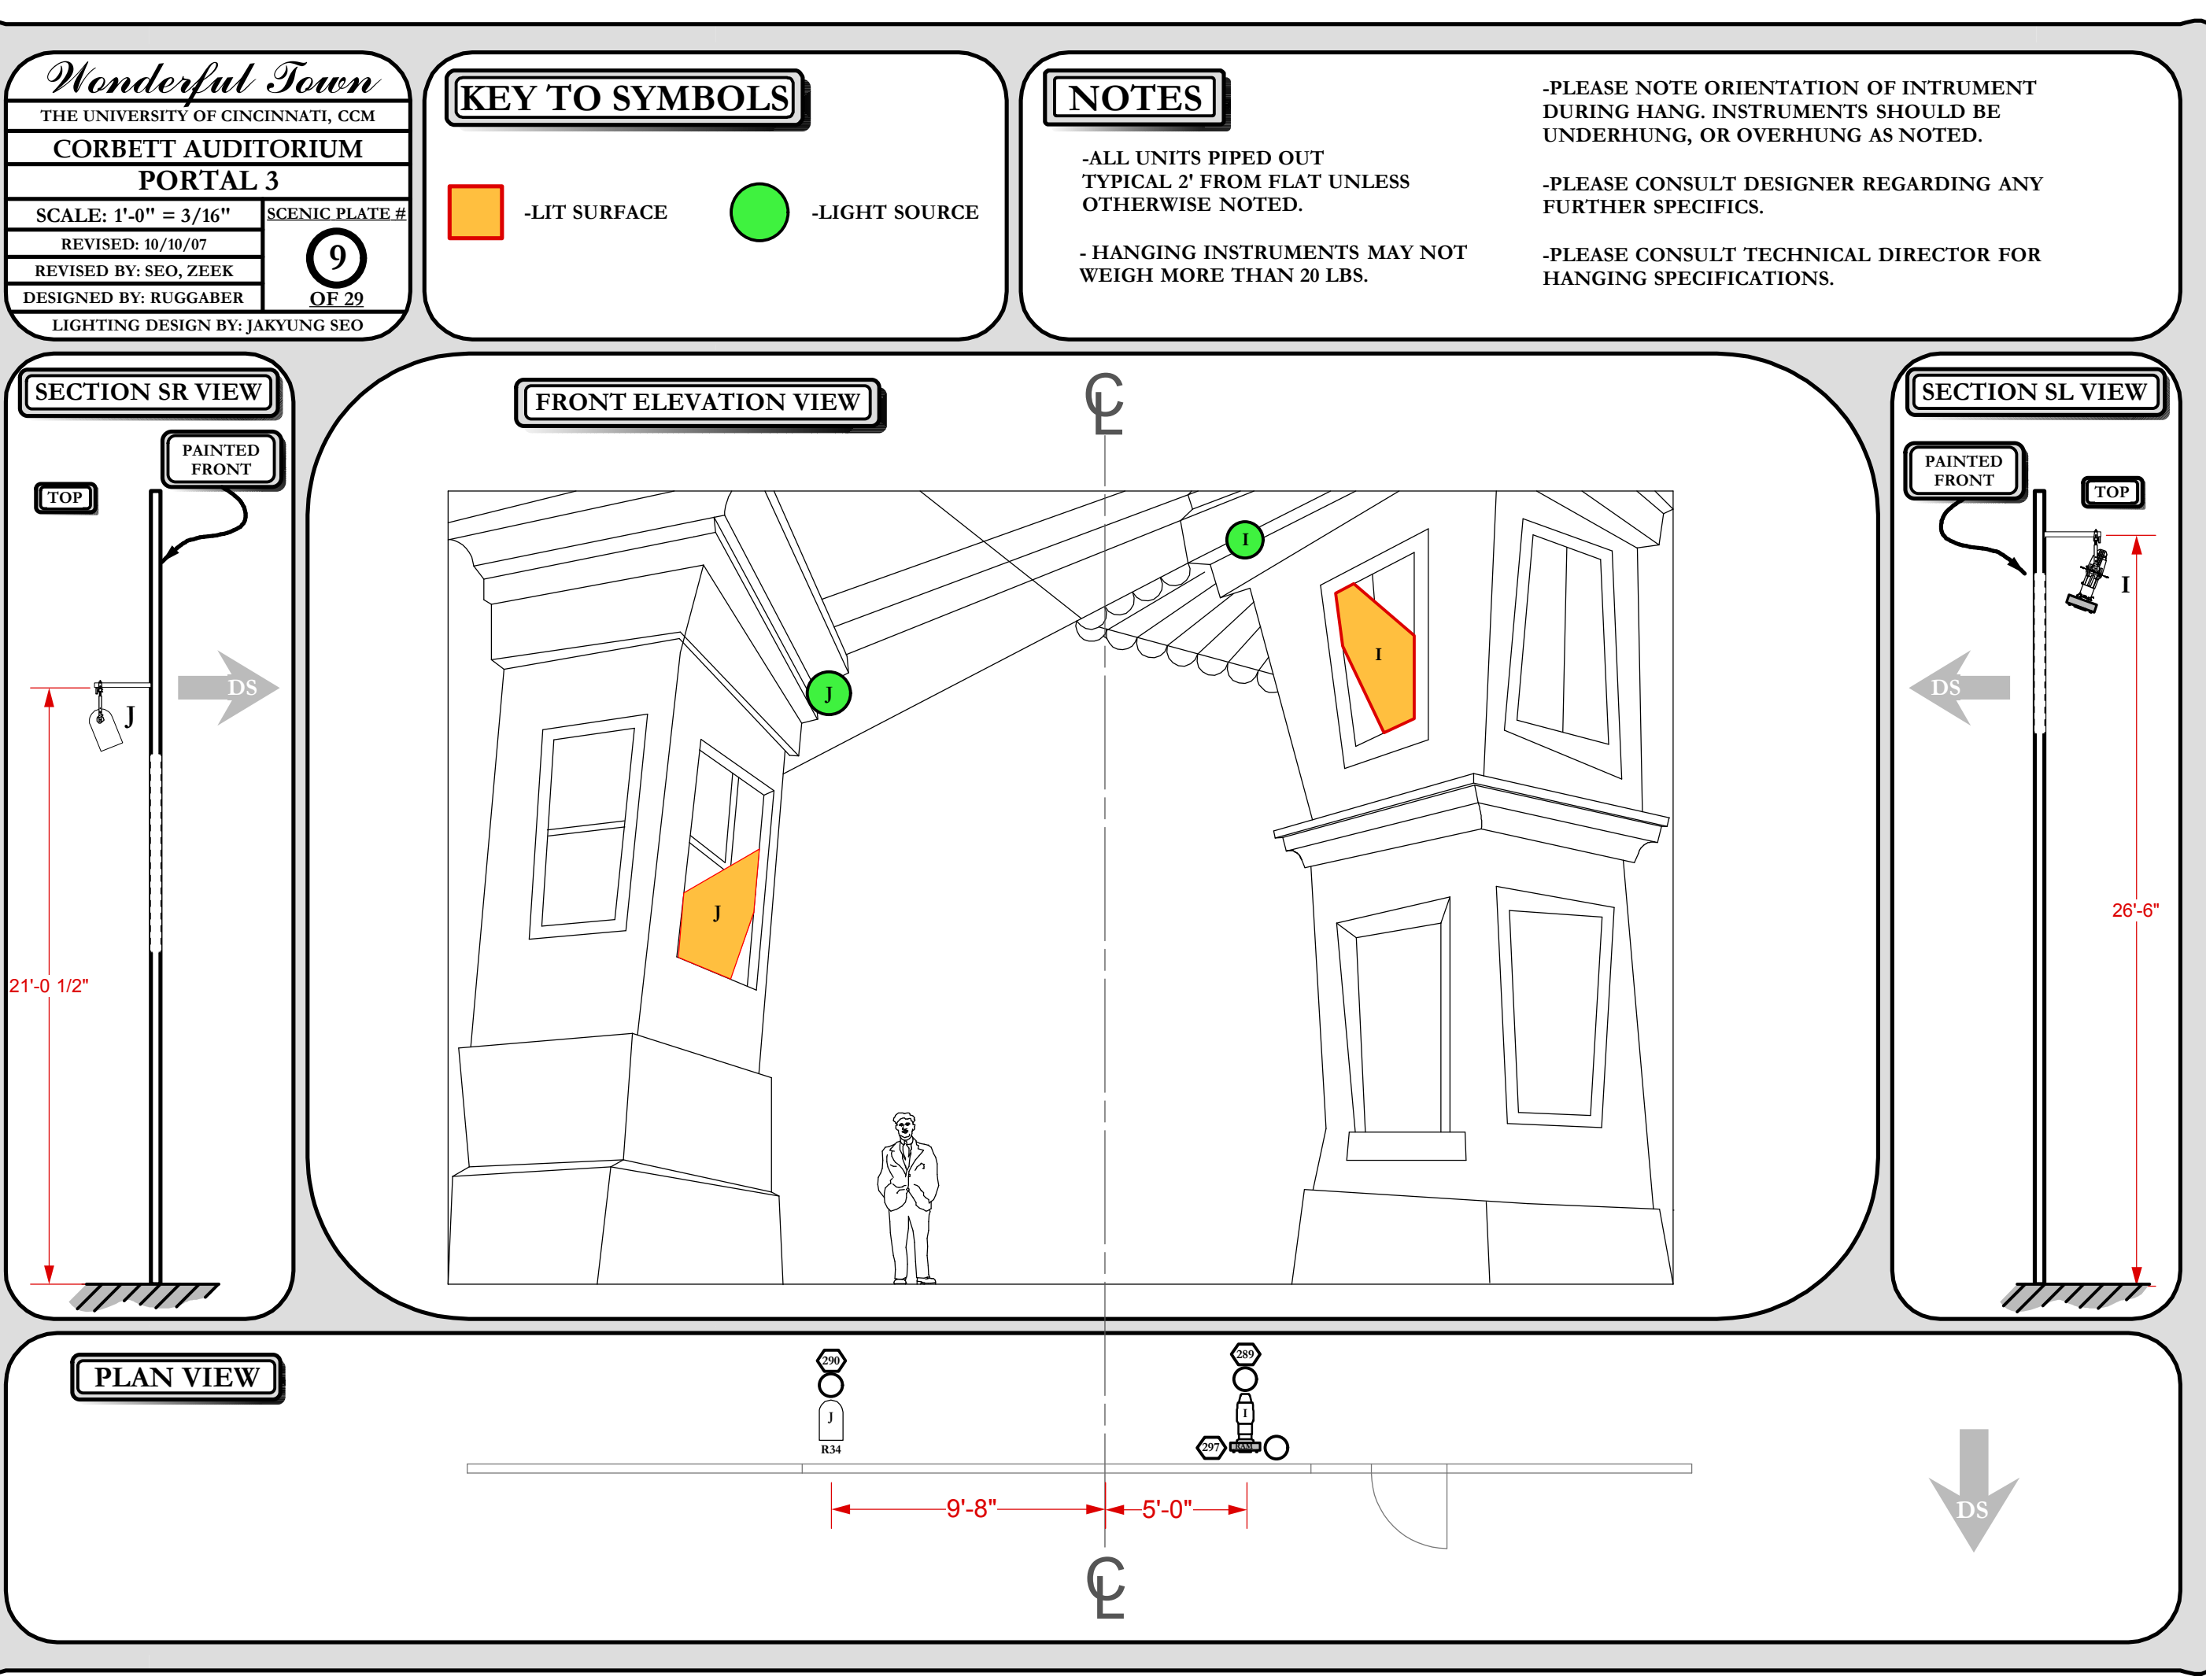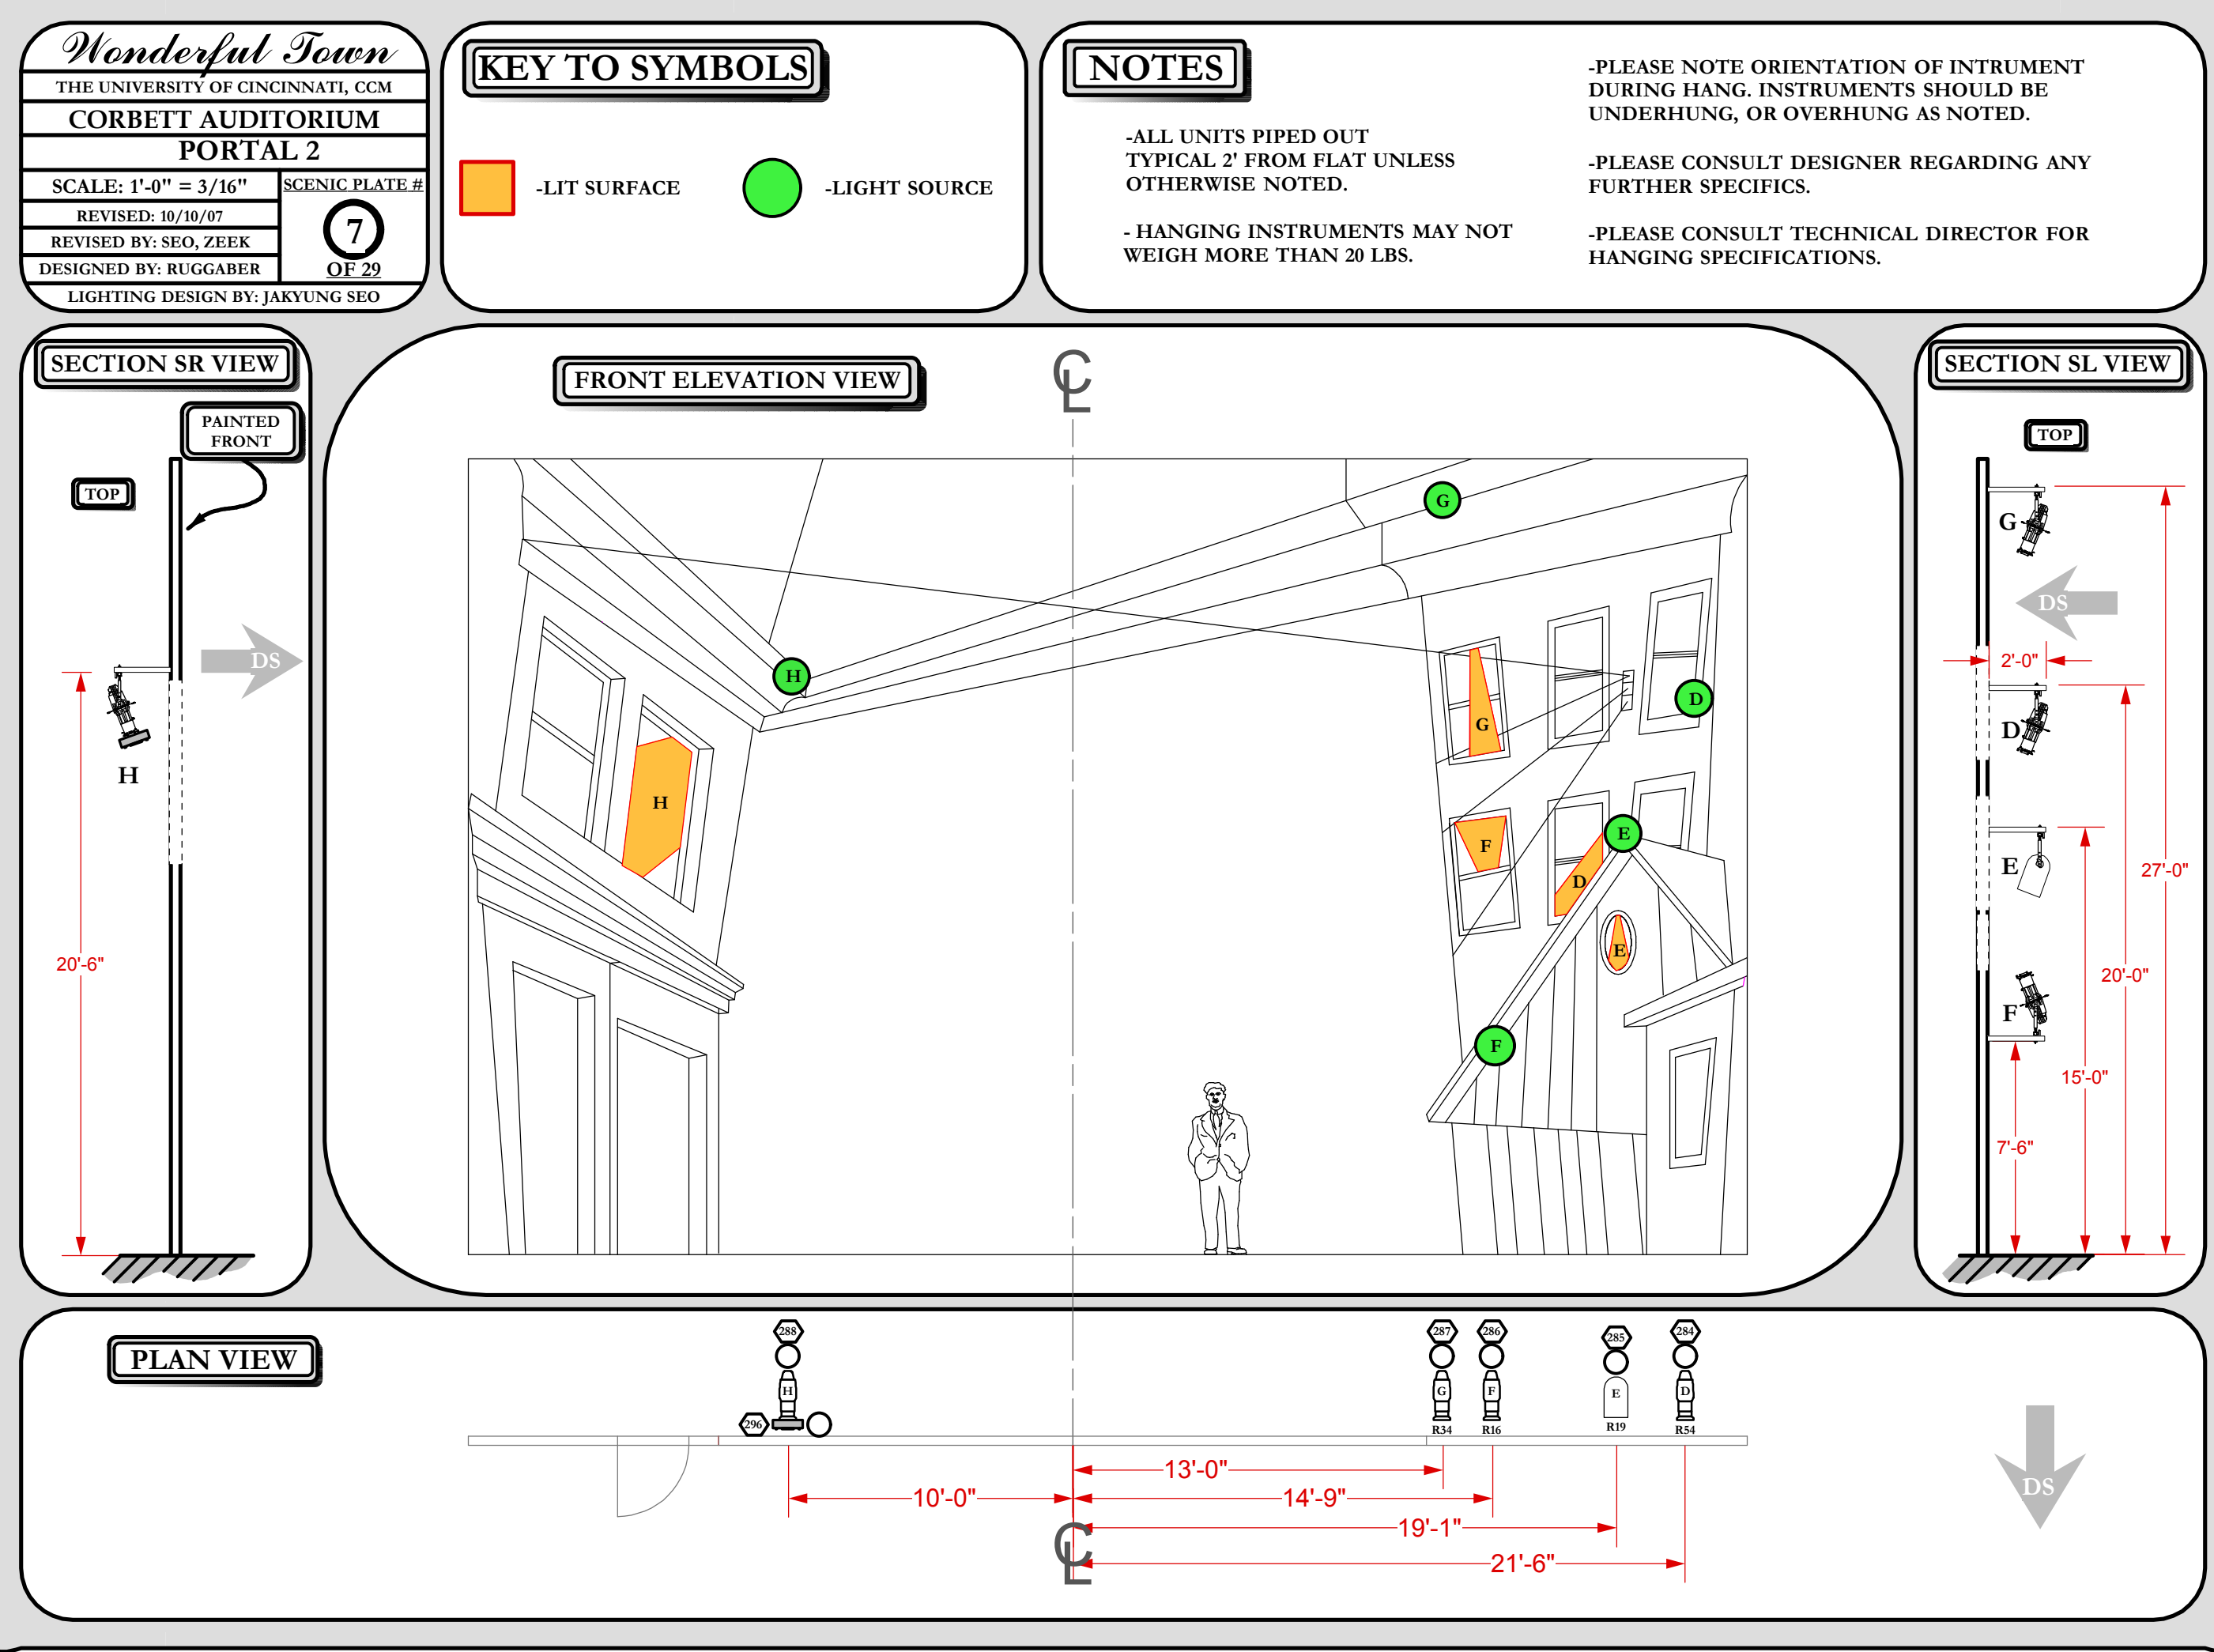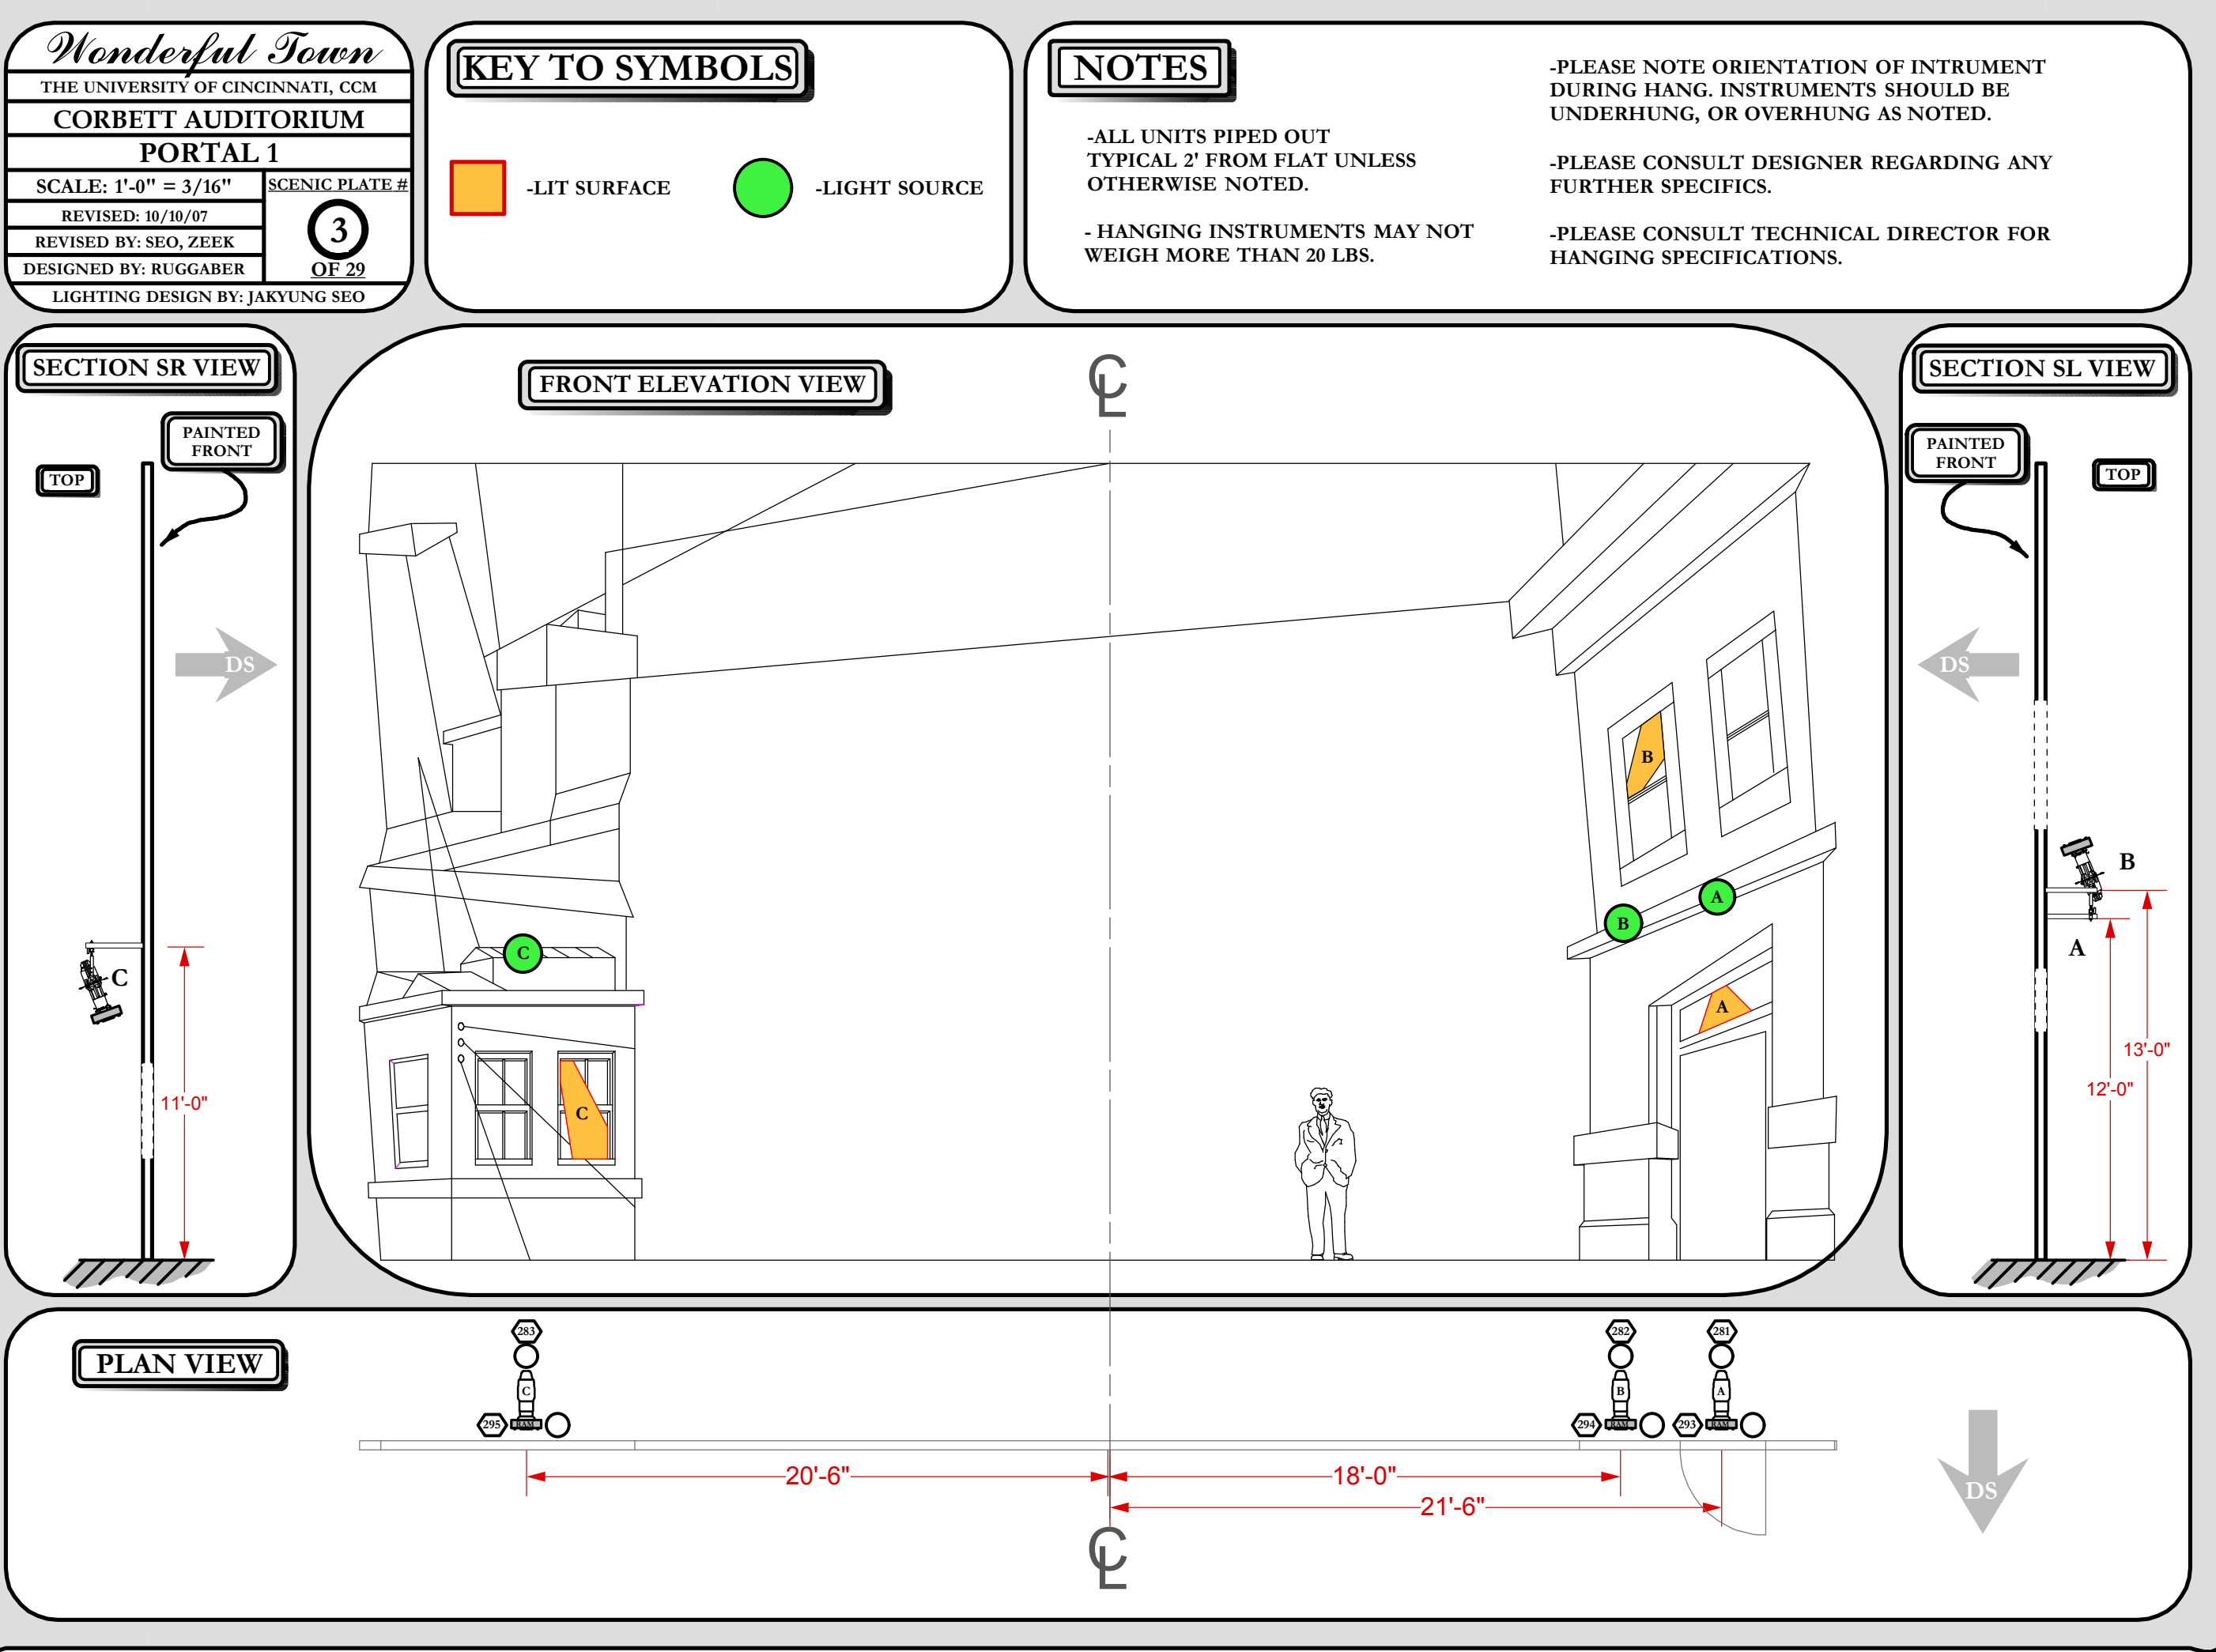

KEY TO SYMBOLS

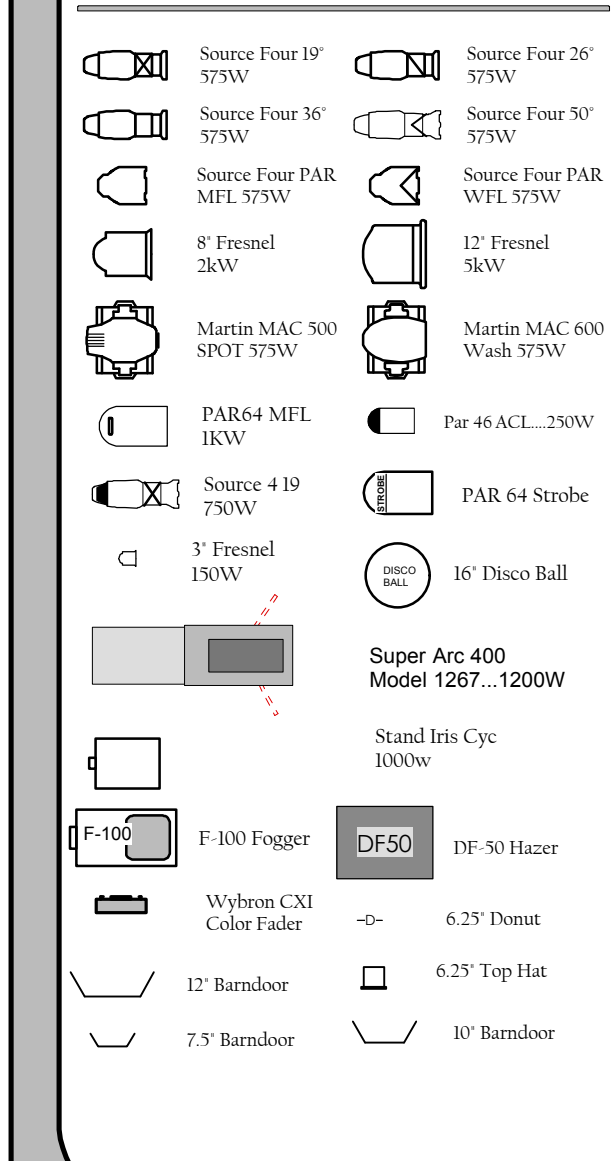

TYPICAL

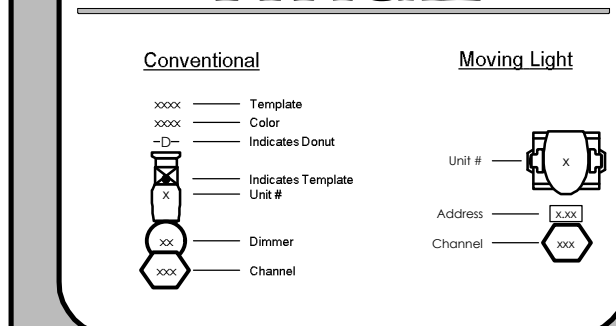

NOTES:

-BEAMS NOT TO SCALE IN RELATION TO PLASTER LINE.
-ALL UNITS ARE ON 18" CENTER UNLESS DIMENSIONED OTHERWISE.
-LINE SETS ARE EXPANDED FOR CLARITY.
-ALL ITEMS SHOWN ON PLOT TO BE INSTALLED AT LOAD-IN (11/3/07).
-PLEASE INCLUDE GEL FRAMES WITH ALL INSTRUMENTS.
-TYPICAL ABBREVIATIONS:
R - ROSCO
G - GAM
L - LEE
NIC - NO COLOR
F - R12
-ALL FIXTURES LABELED WITH 'F' MUST HAVE R12 IN ADDITION TO OTHER GEL.
-ALL INSTRUMENTS IN APRON BOOMS MUST RECEIVE TOP HATS.
-FOR LOAD IN HAVE THE REST OF TOP HATS AND HALF HATS AVAILABLE
-PLEASE HAVE ALL MOVING LIGHTS ADDRESSSED PRIOR TO LOAD-IN
-TRIMS SET FROM SHOW DECK TO BOTTOM OF PIPE
-FOR LOAD IN HAVE EXTRA R12 AND BARN DOORS AVAILABLE
-ALL TRIMS SHOULD BE TAKEN FROM BOTTOM OF PIPE TO SHOW DECK.
-PLEASE TRIM LADDERS FROM BOTTOM PIPE OF THE LADDER TO THE SHOW DECK

University of Cincinnati
COLLEGE-CONSERVATORY OF MUSIC

CORBETT AUDITORIUM



Lighting Design: Jakyung Seo
Director.....Dianne Lala
Conductor.....Roger Grodsky
Scenic Designer.....Brian Ruggaber
Costume Designer.....Reba Senske
Assistant L.D.....Lindsay Van Dyke
Master Electrician.....Robert Moyer

PORTAL PLOT
SCALE: 1/4" = 1'-0"
DRAWN BY: JS, AZ & LVD
File Name: Plate #3 Portals 10.16.07 vandykeL.mcd
Prelim Due: October 15, 2007
Final Due: October 22, 2007
Load In: November 3, 2007
Strike: November 18, 2007


Wonderful Town
THE UNIVERSITY OF CINCINNATI, CCM
CORBETT AUDITORIUM
STUDIO WAGON
SCALE: 1/2" = 1'-0" SCENIC PLATE #
REVISED: 10/16/07
REVISED BY: SEO, ZEEK
DESIGNED BY: RUGGABER
LIGHTING DESIGN BY: JAKYUNG SEO

SCENIC PLATE #	14
OF 29	


NOTES

- ALL UNITS ARE 3" FRESNELS (INKIES)
- PLEASE MOUNT AS SHOWN. LEAVE SUFFICIENT SPACE BETWEEN FIXTURE AND SUPPORT BEAMS TO ALLOW FOCUS OF INTSTRUMENTS
- PLEASE CONFIRM PLACEMENT WITH DESIGNER DURING INSTALLATION.

PLAN VIEW

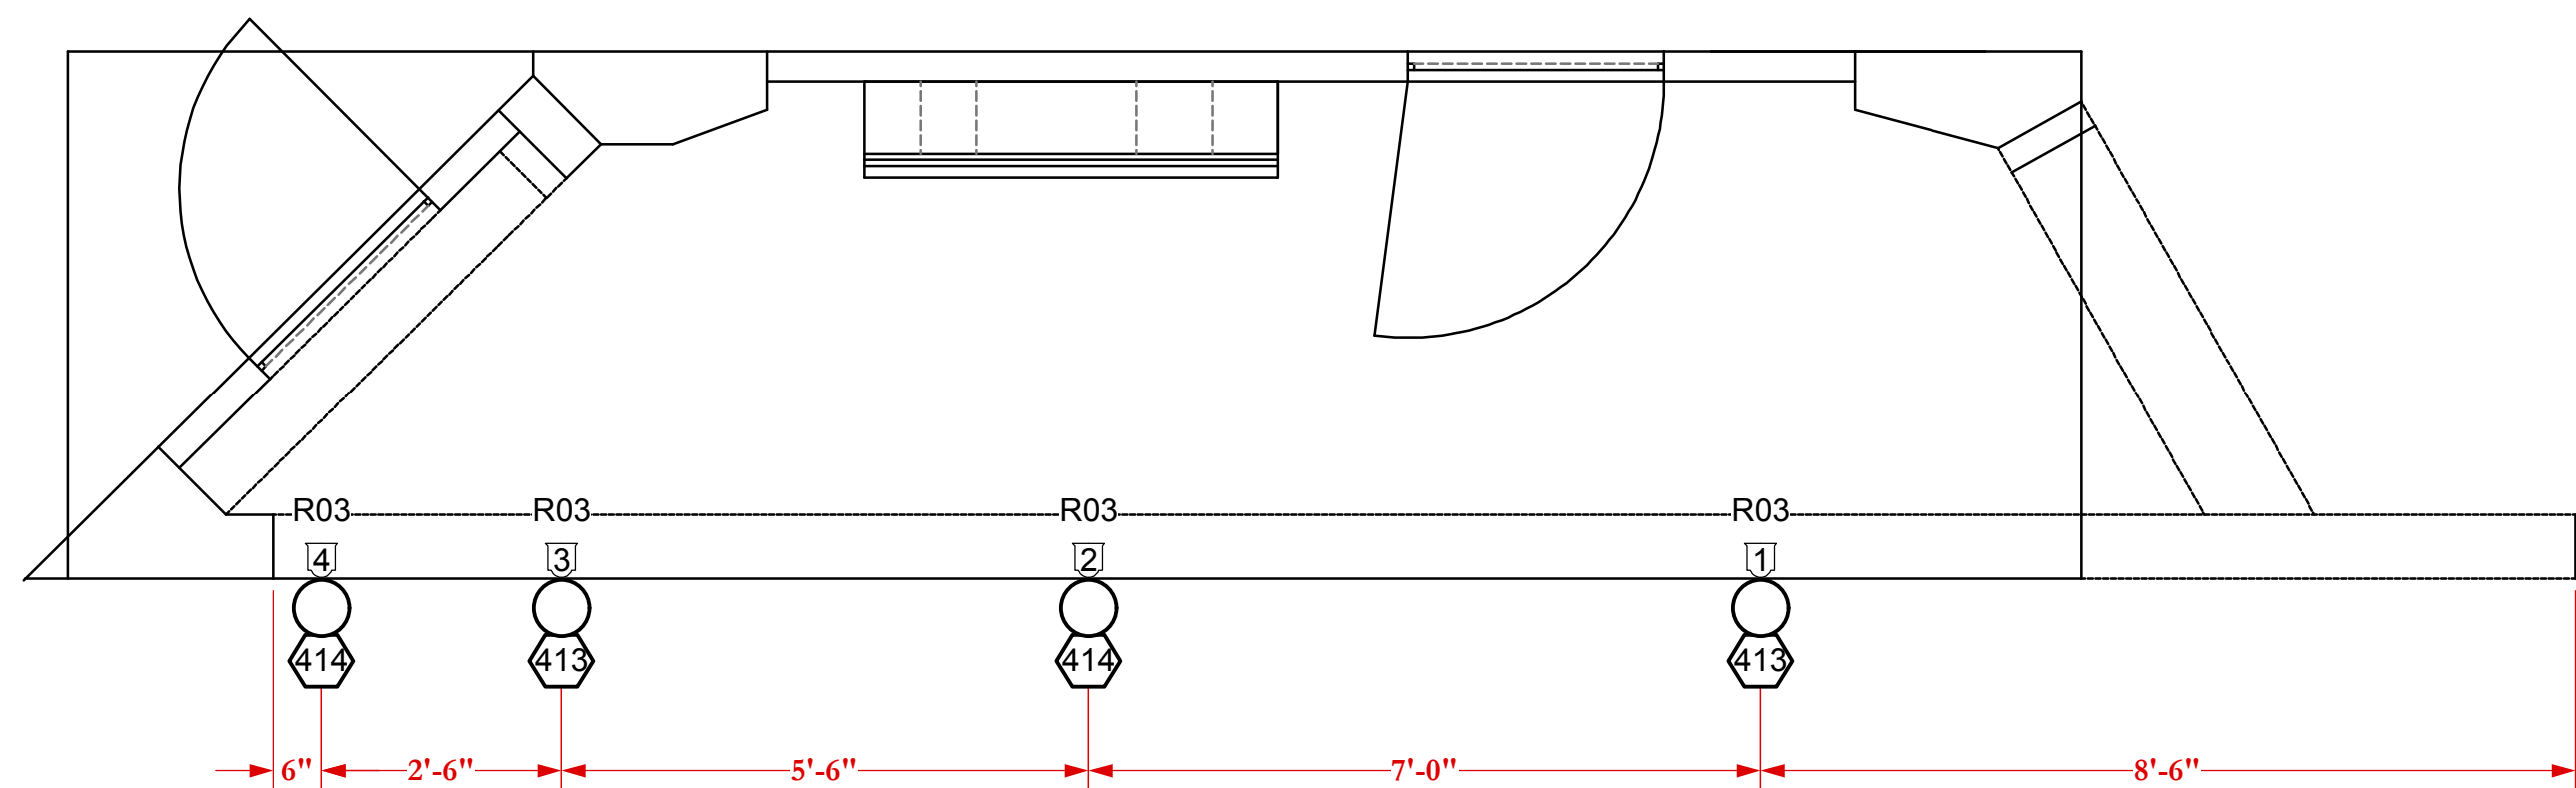

REAR ELEVATION VIEW

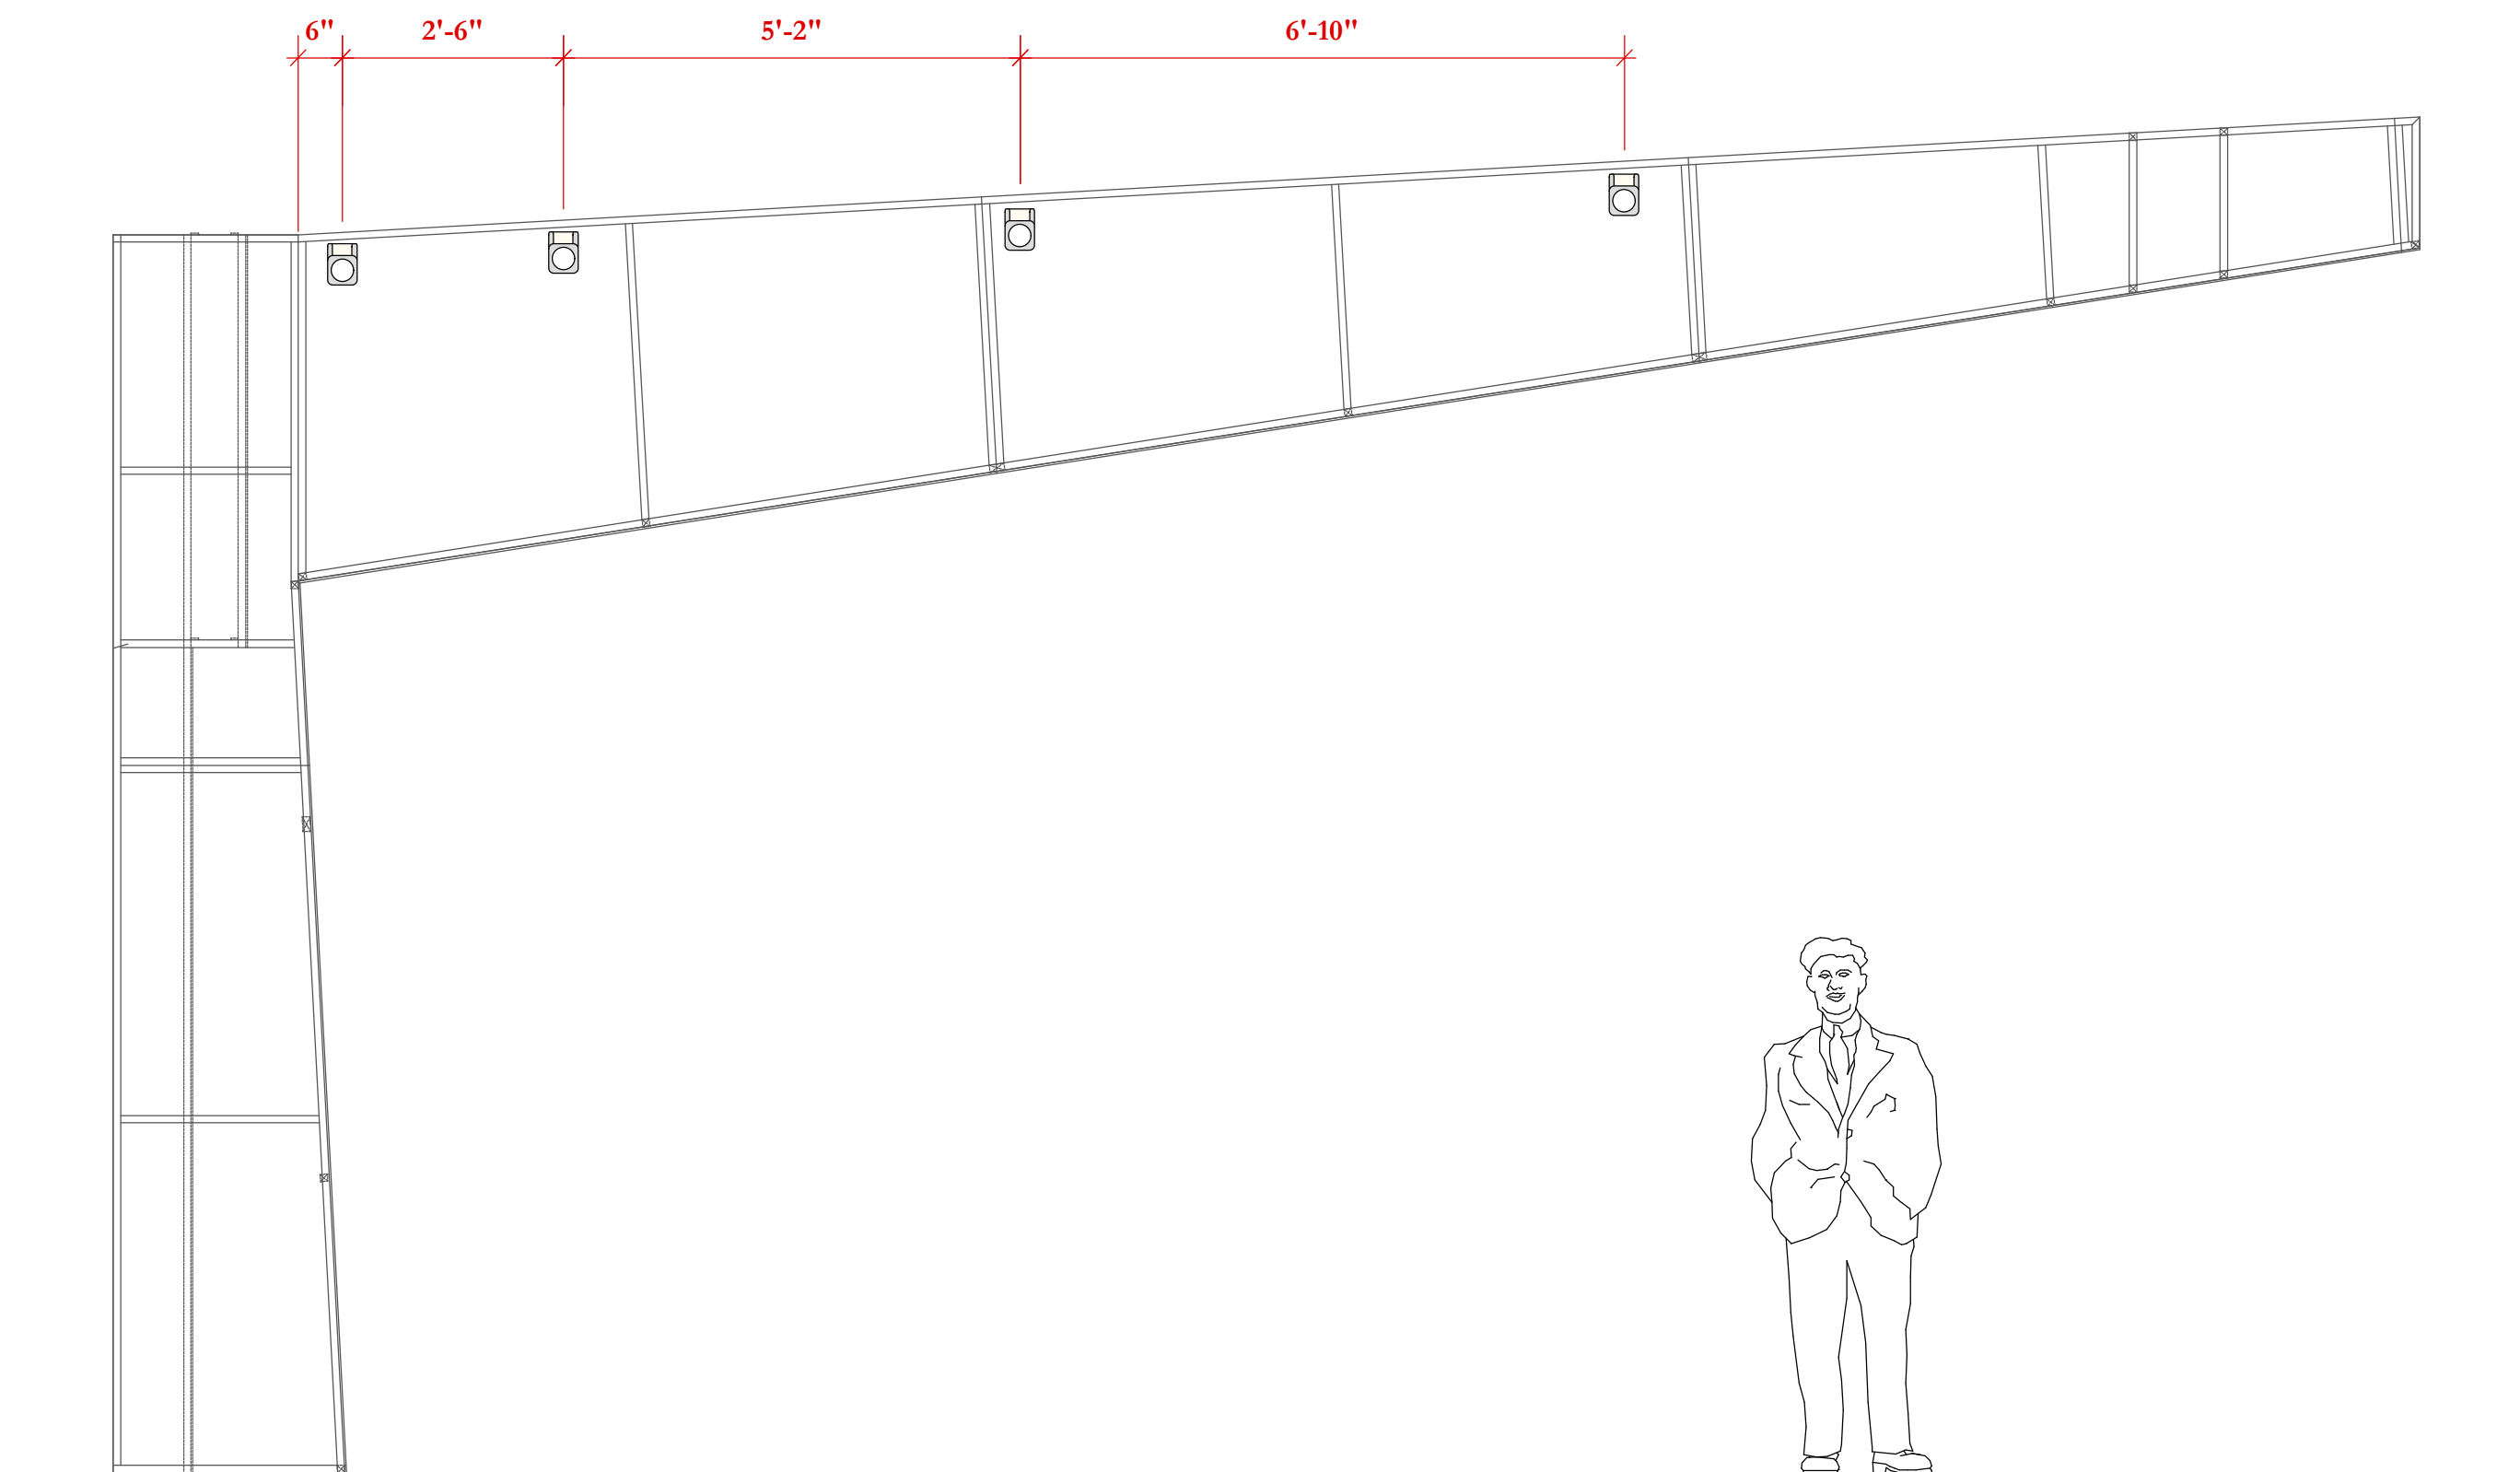


Wonderful Town
THE UNIVERSITY OF CINCINNATI, CCM
CORBETT AUDITORIUM
VILLAGE VORTEX SIGN
SCALE: 1/2" = 1'-0" SCENIC PLATE #
REVISED: 10/16/07
REVISED BY: SEO, ZEEK
DESIGNED BY: RUGGABER
LIGHTING DESIGN BY: JAKYUNG SEO

SCENIC PLATE #	21
OF 29	

NOTES

- TO BE HUNG ON LINESSET 45
- ALL LAMPS TO BE PROVIDED BY SCENIC AND INSTALLED PRIOR TO LOAD-IN. LIGHTING MUST PROVIDE CIRCUITS
- REQUIRES 17 INDIVIDUAL DIMMERS
- WILL FLY IN AND OUT

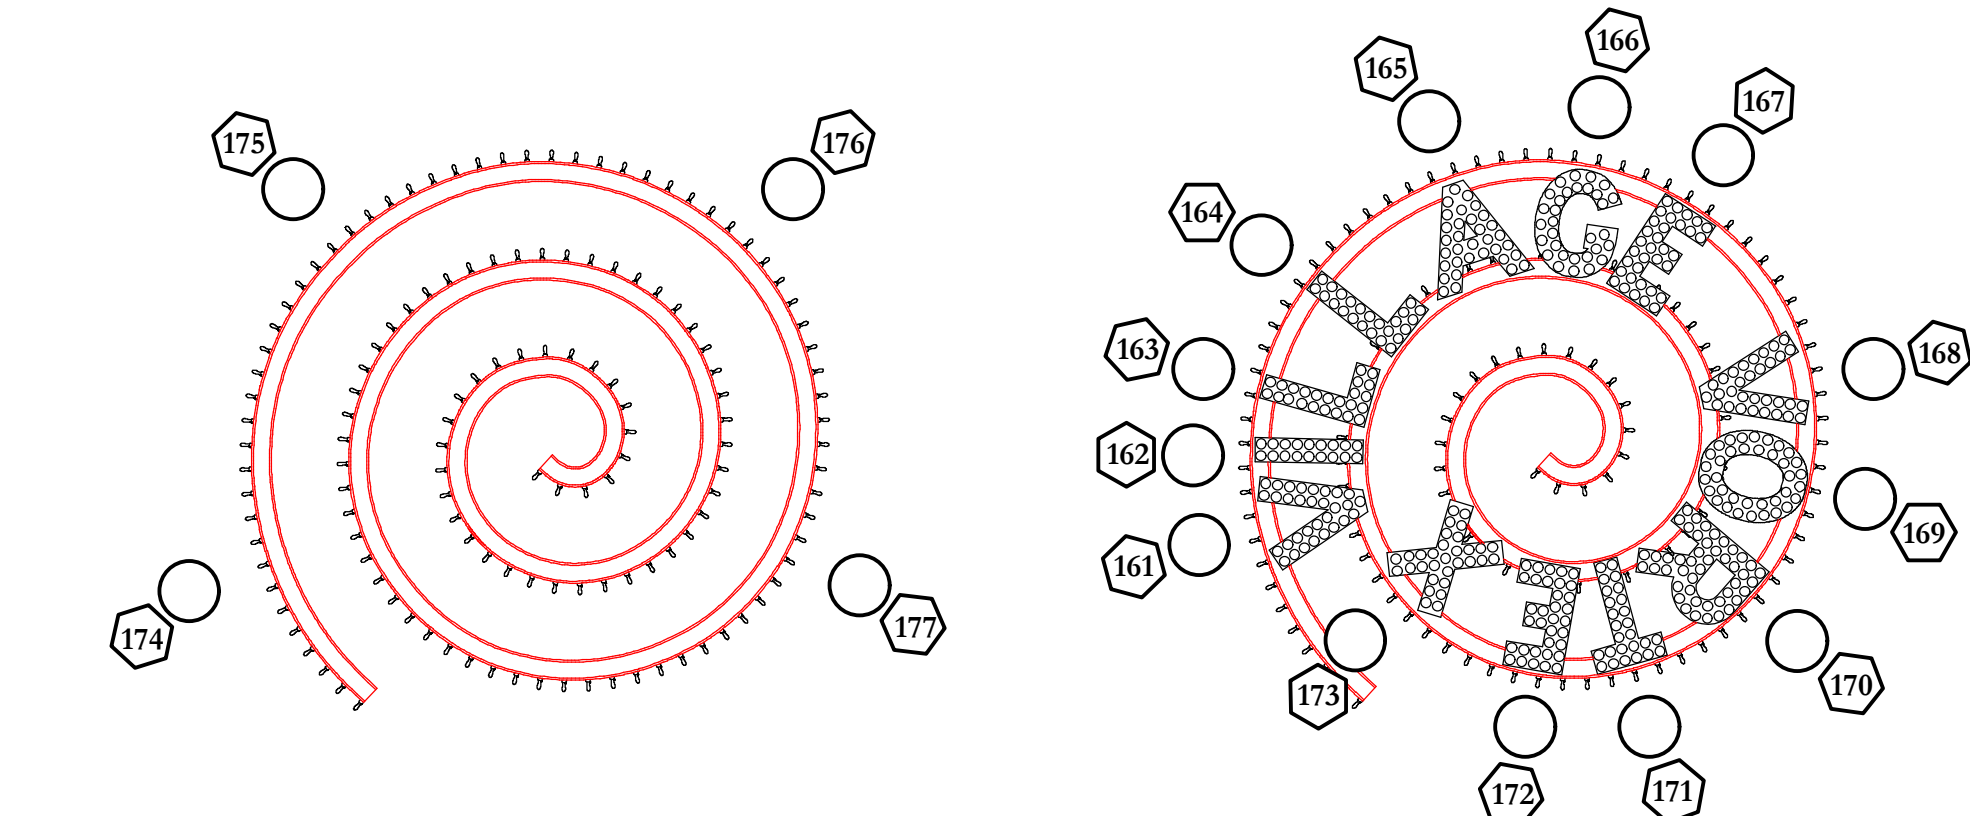

FRONT ELEVATION VIEW


SECTION VIEW

Wonderful Town
THE UNIVERSITY OF CINCINNATI, CCM
CORBETT AUDITORIUM
LAMP POST DETAIL
SCALE: 1/2" = 1'-0" SCENIC PLATE #
REVISED: 10/16/07
REVISED BY: SEO, ZEEK
DESIGNED BY: RUGGABER
LIGHTING DESIGN BY: JAKYUNG SEO

SCENIC PLATE #	17
OF 29	

NOTES

- 1 CIRCUIT TO BE PROVIDED FOR PRACTICAL STREET LAMP.
- LAMP WILL BE 1 150W INCANDESCENT LAMP.
- MUST BE DIMMABLE.
- PLEASE PROVIDE CIRCUIT AT BASE OF LAMP POST, UNDERNEATH BRIDGE.
- PLEASE ENSURE ALL CABLES ARE NEAT. THERE ARE ENTRANCES AND EXITS UNDERNEATH THE BRIDGE.

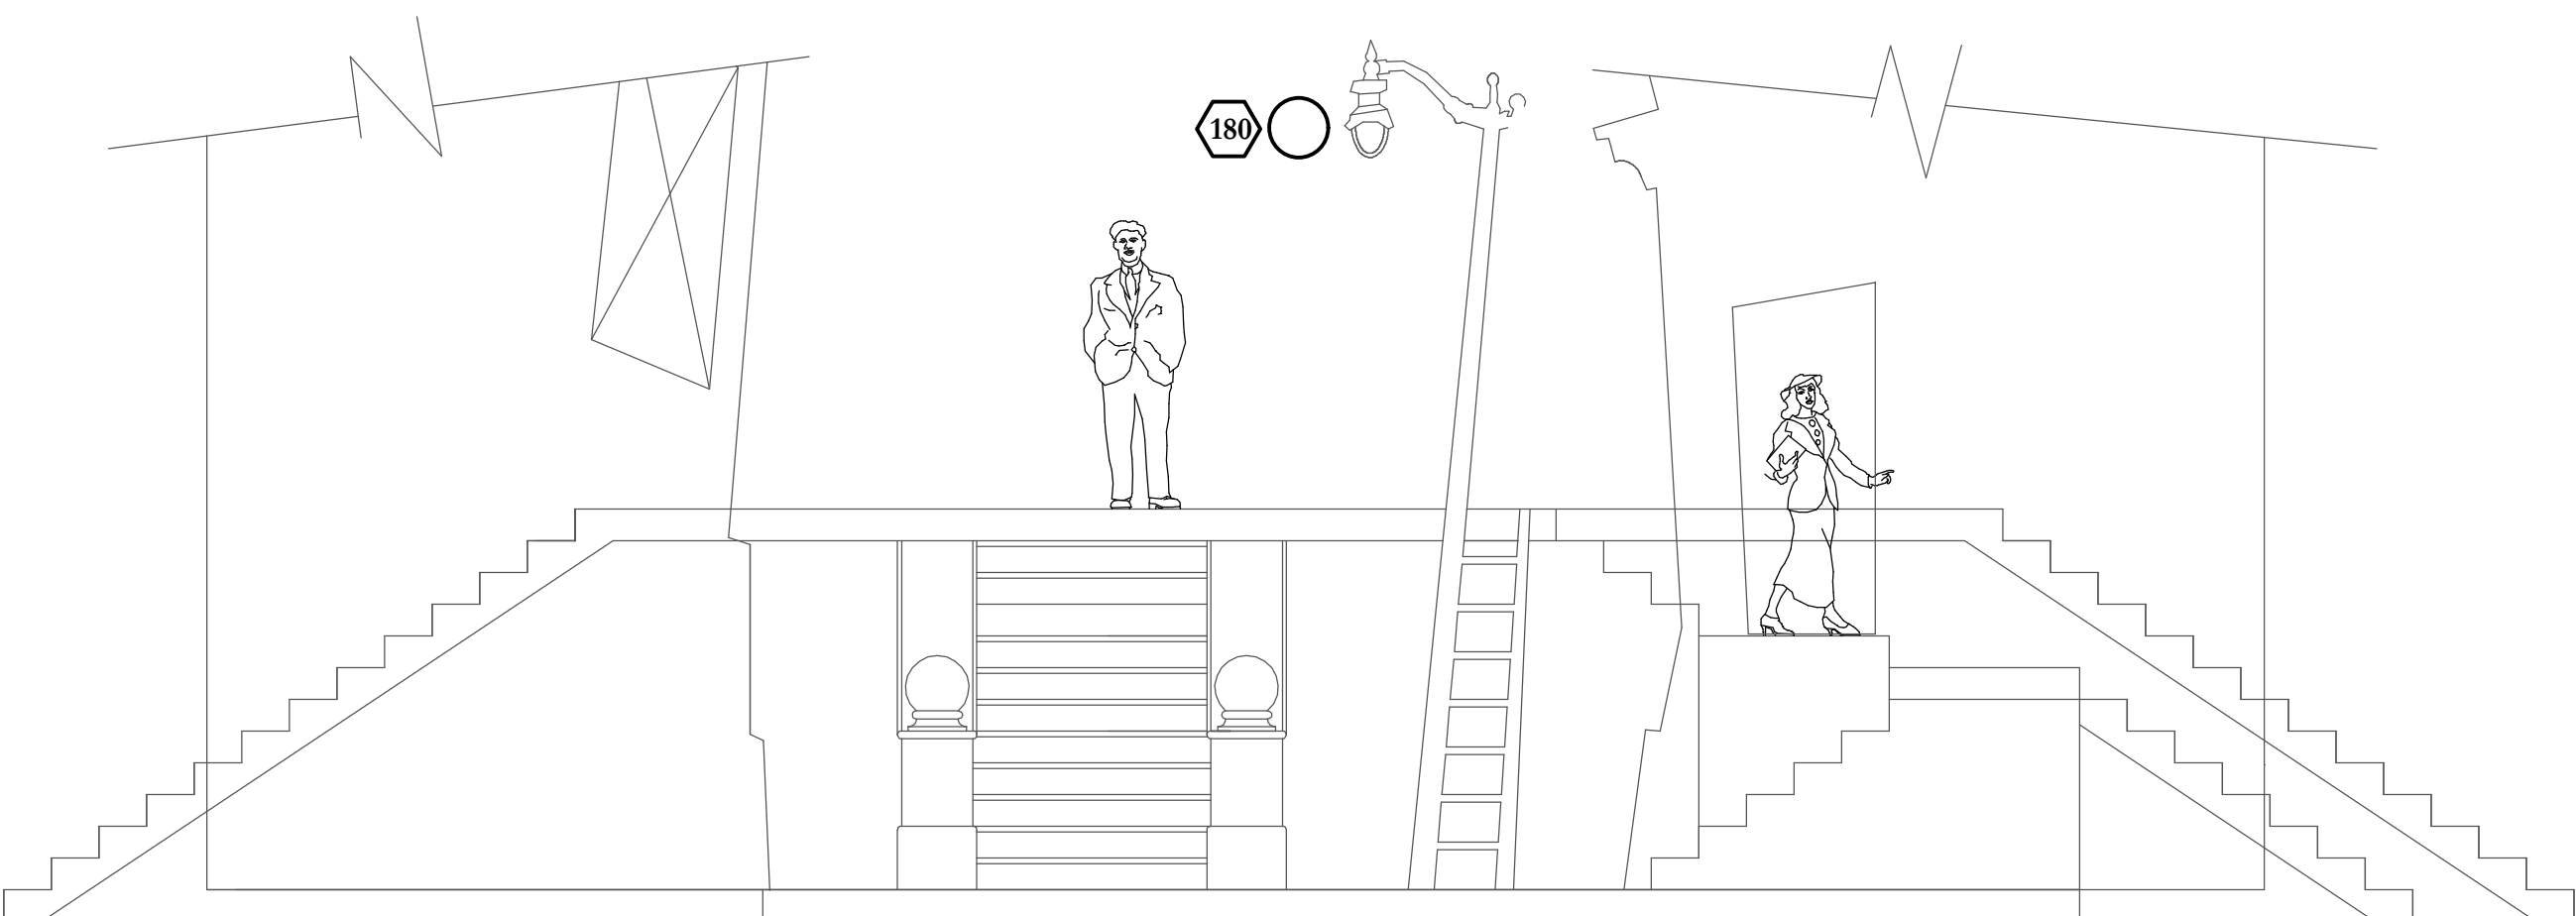

KEY TO SYMBOLS

- | | |
|----------------------------------|--------------------------|
| Source Four 19' 575W | Source Four 26' 575W |
| Source Four 36' 575W | Source Four 50' 575W |
| Source Four PAR MFL 575W | Source Four PAR MFL 575W |
| 8' Fresnel 3kW | 12' Fresnel 3kW |
| Martin MAC 500 SPOT 575W | Martin MAC 600 Wash 575W |
| PAR64 MFL 1KW | Par 48 ACL 250W |
| Source 4 19 750W | PAR 64 Strobe |
| 3' Fresnel 150W | 16' Disco Ball |
| Super Arc 400 Model 1267...1200W | Stand Iris Cyc 1000w |
| F-100 F-100 Fogger | DF50 DF-50 Hazer |
| Wybron CXI Color Fader | 6.25' Denut |
| 12' Barndoor | 6.25' Top-Hat |
| 7.5' Barndoor | 10' Barndoor |

TYPICAL

- | | |
|----------------------|--------------|
| Conventional | Moving Light |
| xxxx Template | Unit # |
| xxxx Color | Address |
| xxxx Indicates Const | Channel |
| Indicates Template | |
| Unit # | |
| Dimmer | |
| Channel | |

NOTES:

- BEAMS NOT TO SCALE IN RELATION TO PLASTER LINE.
- ALL UNITS ARE ON 18" CENTER UNLESS DIMENSIONED OTHERWISE.
- LINE SETS ARE EXPANDED FOR CLARITY.
- ALL ITEMS SHOWN ON PLOT TO BE INSTALLED AT LOAD-IN (11/3/07).
- PLEASE INCLUDE GEL FRAMES WITH ALL INSTRUMENTS.
- TYPICAL ABBREVIATIONS:
 - R - ROSCO
 - G - GAM
 - L - LEE
 - N/C - NO COLOR
 - F - R12
- ALL FIXTURES LABELED WITH "F" MUST HAVE R12 IN ADDITION TO OTHER GEL.
- ALL INSTRUMENTS IN APRON BOOMS MUST RECEIVE TOP HATS.
- FOR LOAD IN HAVE THE REST OF TOP HATS AND HALF HATS AVAILABLE
- PLEASE HAVE ALL MOVING LIGHTS ADDRESSED PRIOR TO LOAD-IN.
- TRIMS SET FROM SHOW DECK TO BOTTOM OF PIPE
- FOR LOAD IN HAVE EXTRA R12 AND BARN DOORS AVAILABLE
- ALL TRIMS SHOULD BE TAKEN FROM BOTTOM OF PIPE TO SHOW DECK
- PLEASE TRIM LADDERS FROM BOTTOM PIPE OF THE LADDER TO THE SHOW DECK

University of Cincinnati
COLLEGE-CONSERVATORY OF MUSIC

CORBETT AUDITORIUM



Lighting Design: *Jakyung Seo*
Director:.....Dianne Lala
Conductor:.....Roger Grodsky
Scenic Designer:.....Brian Ruggaber
Costume Designer:.....Reba Senske
Assistant L.D.:.....Lindsay Van Dyke
Master Electrician:.....Robert Moyer

DETAILS

SCALE: 1/4" = 1'-0"

DRAWN BY: JS, AZ & LVD

File Name: Plate #4 Details 10.20.07 ver 2 zeek

Prelim Due:	October 15, 2007
Final Due:	October 22, 2007
Load In:	November 3, 2007
Strike:	November 18, 2007

PLATE

4

OF

5
